


CLARK'S FERRY SUBDIVISION

12/2018

CLARK'S FERRY DRIVE

502-01 CONCRETE PAVEMENT (PAGE 1) (1-18-08)
502-01 CONCRETE PAVEMENT (PAGE 2) (1-18-08)
502-01 CONCRETE PAVEMENT (PAGE 3) (1-18-08)
701-01 BEDDING AND BACKFILL DETAILS FOR STORM DRAINAGE (2-8-08)
702-10 SINGLE RETICULINE INLET (12-6-10)
702-10 SINGLE RETICULINE INLET (12-6-10)
702-20 CAST IRON GRATE INLET AND JUNCTION BOX (12-6-10)
702-31 CONCRETE JUNCTION BOX (12-6-10)
702-99 FRAMES GRATES AND COVERS FOR INLETS AND MANHOLES (3 SHEETS) (8-11-08)
801-01 BEDDING AND BACKFILL DETAILS (4-17-15)
802-01 SANITARY SEWER CLEANOUT DETAILS (8-1-11)
803-01 SANITARY SEWER MANHOLE (3 SHEETS) (8-1-11)
903-01 STORMWATER POLLUTION PREVENTION (11 SHEETS) (2-25-08)
905-40 END OF ROAD INSTALLATIONS (5 SHEETS) (1-9-08)
907-01 SIDEWALK AND CURB RAMPS FOR THE HANDICAPPED (8-8-08)

15) BASE FLOOD ELEV: 26.0'
INUNDATION ELEV: 25.5'
LOWEST STREET ELEV: 26.27'
PROPOSED SLAB ELEV: 27.0'


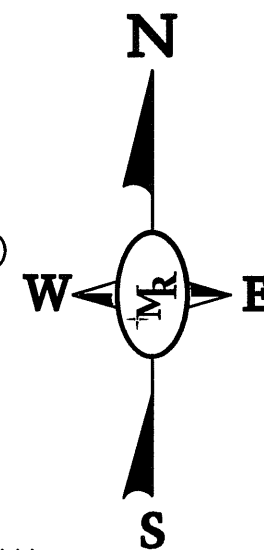


LOCATION MAP

SHEET SUMMARY

Sheet Number	Sheet Title
1	TITLESHEET
2	TYPICAL SECTION & DETAILS
3	WATERSHED LAYOUT
4	DRAINAGE LAYOUT
5	SEWER LAYOUT
6	CLARK'S FERRY DR. PLAN & PROFILE
7	CLARK'S FERRY DR. PLAN & PROFILE
8	OUTFALL A PLAN & PROFILE
9	WEST DITCH PLAN & PROFILE
10	EAST DITCH PLAN & PROFILE
11	MISC. DRAINAGE PLAN & PROFILE
12	SEWER PLAN & PROFILE
13	DETAILED GRADING
14	TRAFFIC CONTROL LAYOUT
15	EROSION CONTROL LAYOUT
16	CROSS SECTIONS
17	CROSS SECTIONS
18	APPROVED PRELIMINARY PLAT

Carey Chauvin 1/4/19
CAREY CHAUVIN
DEPARTMENT OF DEVELOPMENT DIRECTOR
DATE

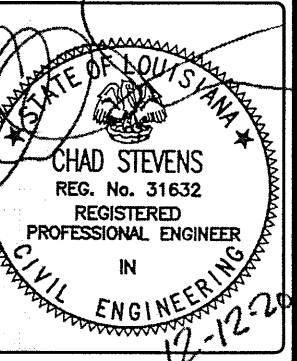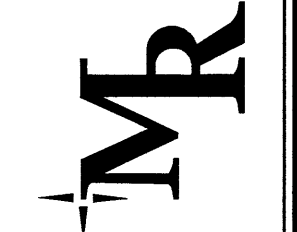


HOO SHOO TOO RD.
BATON ROUGE
EAST BATON ROUGE PARISH
TITLESHEET

DESIGNED	JDB
CHECKED	CMS
DETAILED	JDB
CHECKED	CMS
DATE	12/2018
SHEET	1 OF 17

[illegible]

D:\MR DROPBOX\ORIPROJ (MRIS PROJECTS)\MRIS\PROJECTS\CLARK'S FERRY\DWG\GEN\TYPICAL SECTION & DETAILS.DWG DEC-13-2018 JDB DRAFTING\DESIGN




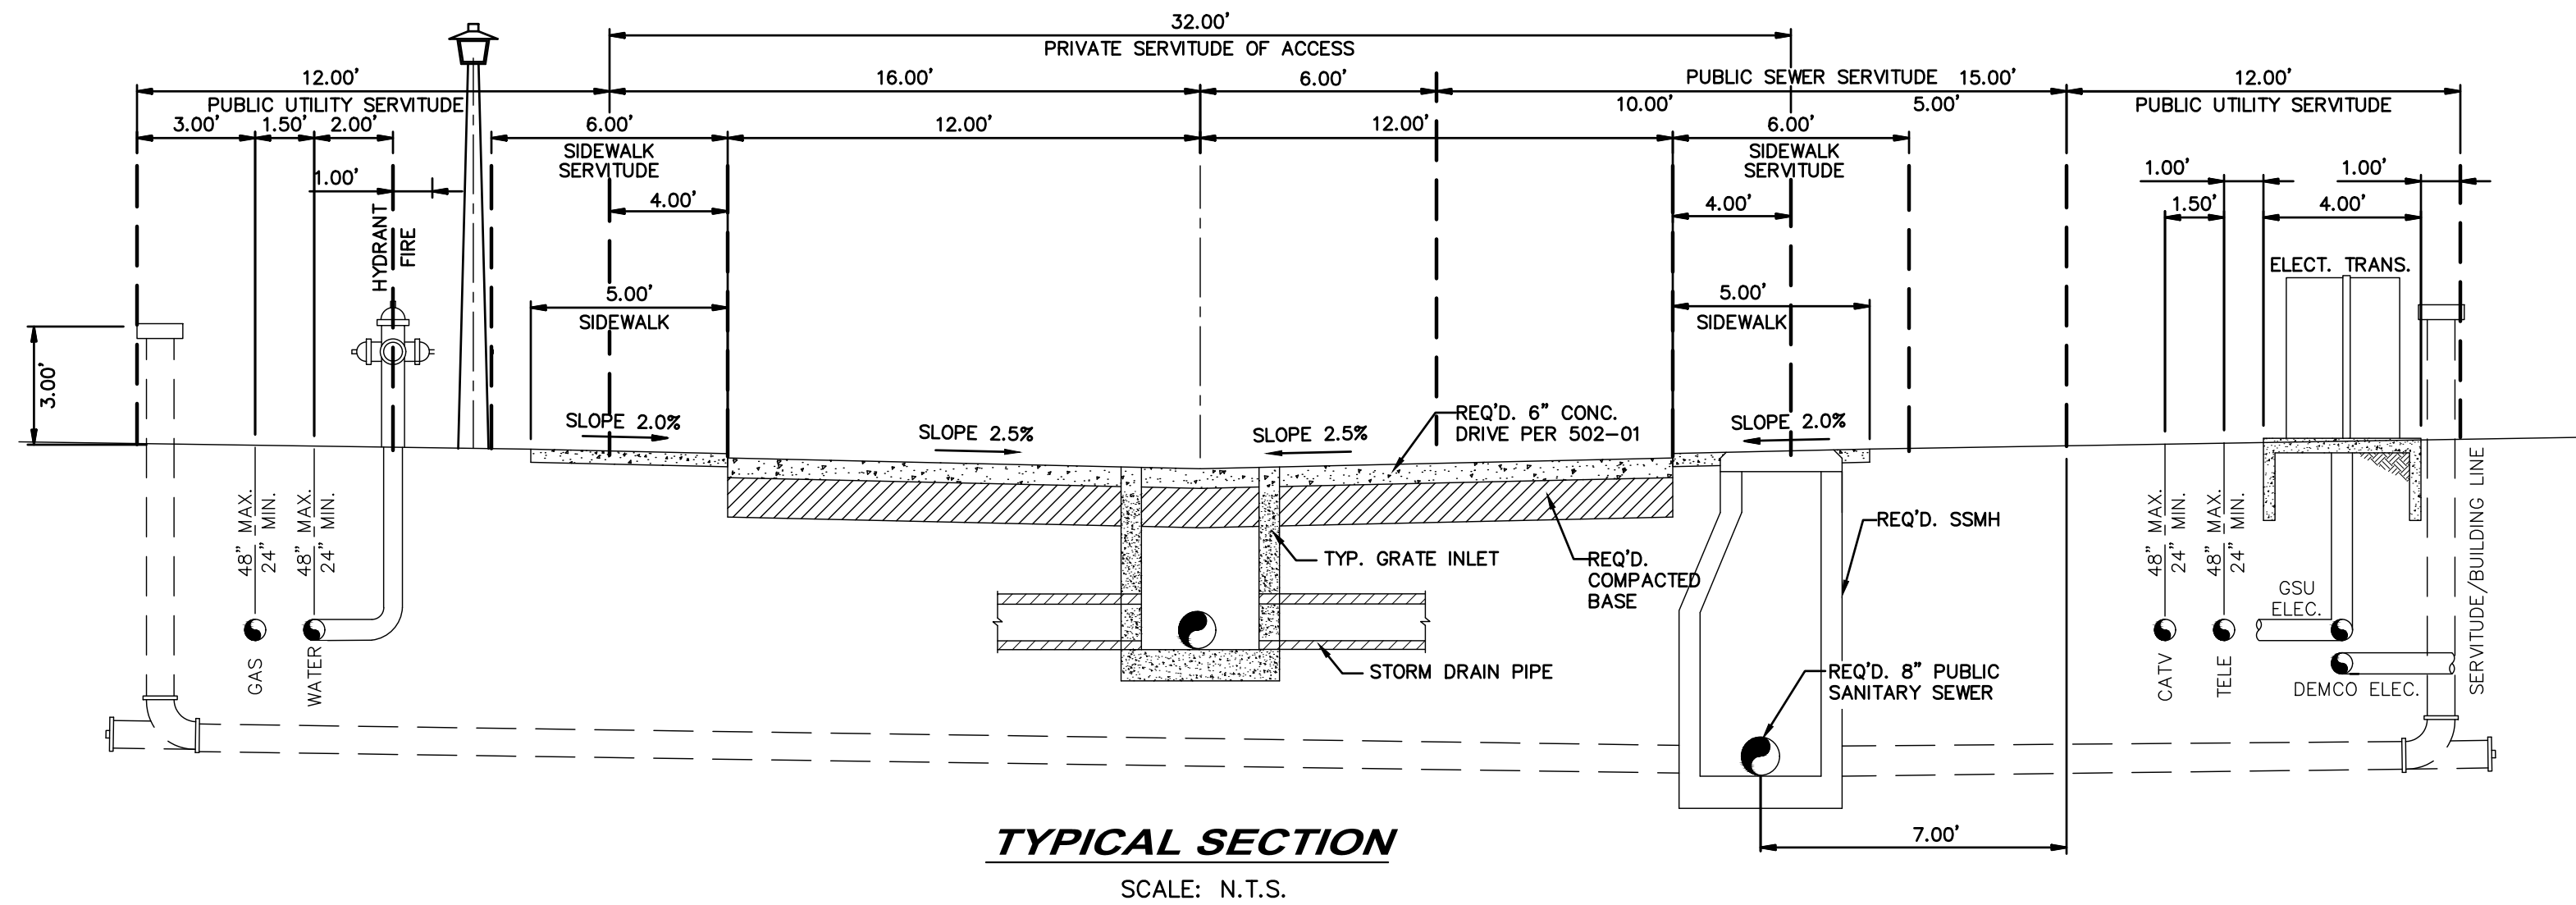


GENERAL NOTES:

1. EMBANKMENT, WHERE REQUIRED, SHALL BE PLACED IN 8" LOOSE LIFTS AND COMPACTED TO 95% MAXIMUM DENSITY AT OPTIMUM MOISTURE AS DETERMINED BY STANDARD PROCTOR TEST. ALL COSTS FOR EMBANKMENT CONSTRUCTION SHALL BE INCLUDED IN PAY ITEM FOR SAME.
2. BEFORE STARTING ANY EMBANKMENT CONSTRUCTION, REMOVE ALL VEGETATIVE MATTER AND THOROUGHLY SCARIFY AREA TO A MINIMUM DEPTH OF 6" AND RECOMPACT TO 95% MAXIMUM DENSITY (AS DETERMINED BY STANDARD PROCTOR) AT OPTIMUM MOISTURE (NO DIRECT PAY).
3. THE CONSTRUCTION FEATURES SHOWN HEREON (OTHER THAN STREETS, DRAINAGE AND SANITARY SEWERS) ARE NOT A PART OF THIS PROJECT. IF PROVIDED WITHIN THE DEVELOPMENT, EACH UTILITY SHALL BE INSTALLED IN THE SPACE INDICATED.
4. THIS SPACE ALLOCATION PLAN DOES NOT RELIEVE ANY UTILITY COMPANY FROM COMPLYING WITH ANY APPLICABLE CODES.
5. ALL ELECTRIC CABLES MUST HAVE A MINIMUM COVER OF 36".
6. PRIOR TO THE PLACEMENT OF PAVEMENT, THE CONTRACTOR SHALL PROVIDE A 12 C.Y. TANDEM DUMP TRUCK FULLY LOADED WITH SAND TO PROOF ROLL THE BASE. THE ENGINEER, THE TESTING LABORATORY AND THE CITY-PARISH OF EAST BATON ROUGE SHALL INSPECT THE PROOF ROLL OF THE BASE. NO PAVEMENT SHALL BE PLACED UPON THE BASE MATERIAL UNTIL SUCH TIME AS AS THE CONTRACTOR HAS OBTAINED WRITTEN APPROVAL FROM THE ENGINEER.
7. UNLESS OTHERWISE DIRECTED BY THE ENGINEER, ALL ROADWAY EXCAVATION SHALL BE DUMPED ON THE ADJACENT LOTS AND EVENLY SPREAD AND GRADED TO PROMOTE POSITIVE DRAINAGE.
8. THE CONTRACTOR SHALL NOTIFY THE CITY-PARISH OF EAST BATON ROUGE, THE TESTING LABORATORY AND THE ENGINEER, IN WRITING, PRIOR TO BEGINNING ANY CONSTRUCTION.
9. ALL TRENCHES FOR STORM DRAINAGE, SANITARY SEWER, SANITARY SEWER SERVICES, AND FORCE MAINS SHALL BE BACKFILLED WITH APPROVED BEDDING MATERIAL, FOR ADDITIONAL INFORMATION REFER TO 701-01 & 801-01.
10. ALL EXCESS EXCAVATION IS TO BE SPREAD ON-SITE AT THE DIRECTION OF THE PROJECT ENGINEER.
11. EXISTING UTILITIES SHOWN ON THE PLANS ARE FOR INFORMATIONAL PURPOSES ONLY. IT IS THE CONTRACTOR'S RESPONSIBILITY TO DETERMINE THE HORIZONTAL AND VERTICAL LOCATION OF ALL EXISTING UTILITIES PRIOR TO PERFORMING ANY EXCAVATION OR TRENCHING.
12. THE CONTRACTOR SHALL INSTALL AND MAINTAIN ADEQUATE CONSTRUCTION SIGNAGE AND BARRICADES IN ACCORDANCE WITH THE MANUAL OF UNIFORM TRAFFIC CONTROL DEVICES.
13. ALL MANHOLE AND GRATE TOP ELEVATIONS LISTED ARE APPROXIMATE. CONTRACTOR IS RESPONSIBLE FOR SETTING ALL TOP ELEVATIONS FLUSH WITH THE FINISHED GRADE FOR POSITIVE DRAINAGE.
14. AFTER STREETS HAVE BEEN ROUGH GRADED, TESTING LAB SHALL TAKE SOIL SAMPLES AND RUN LABORATORY TEST TO DETERMINE PROPER % OF LIME TO ACHIEVE BASE COURSE STRENGTH AS REQUIRED BY STANDARD SPECIFICATIONS.
15. THE CONSTRUCTION MATERIALS AND PROCEDURES UTILIZED FOR THE PROPOSED STREETS SHALL MEET OR OR EXCEED THE MINIMUM REQUIREMENTS AS SET FORTH AND ESTABLISHED BY THE CITY-PARISH OF EAST BATON ROUGE.
16. ALL DRAINAGE & SEWER MANHOLE COVERS TO BE PLACED COMPLETELY IN OR COMPLETELY OUT OF SIDEWALK.

SIDEWALK NOTES:

1. ALL SIDEWALK SHALL BE INSTALLED 1.5" ABOVE THE BACK OF CURB.

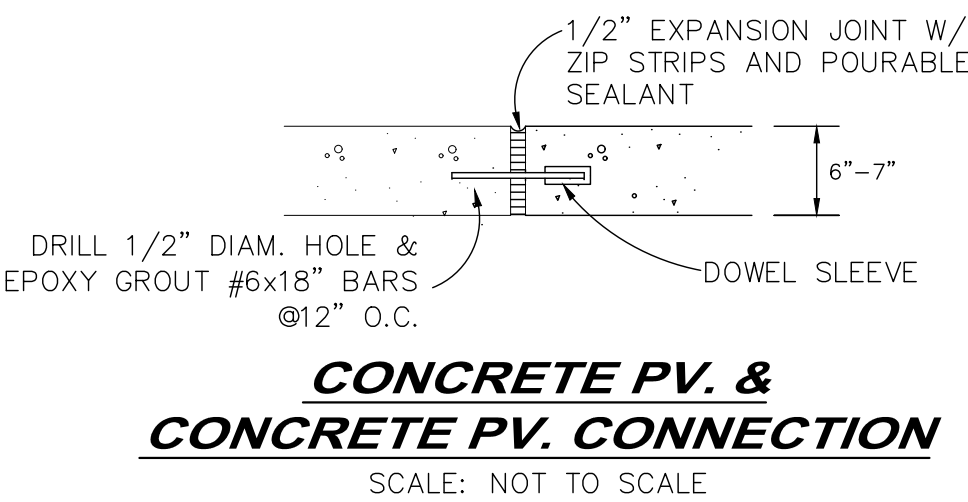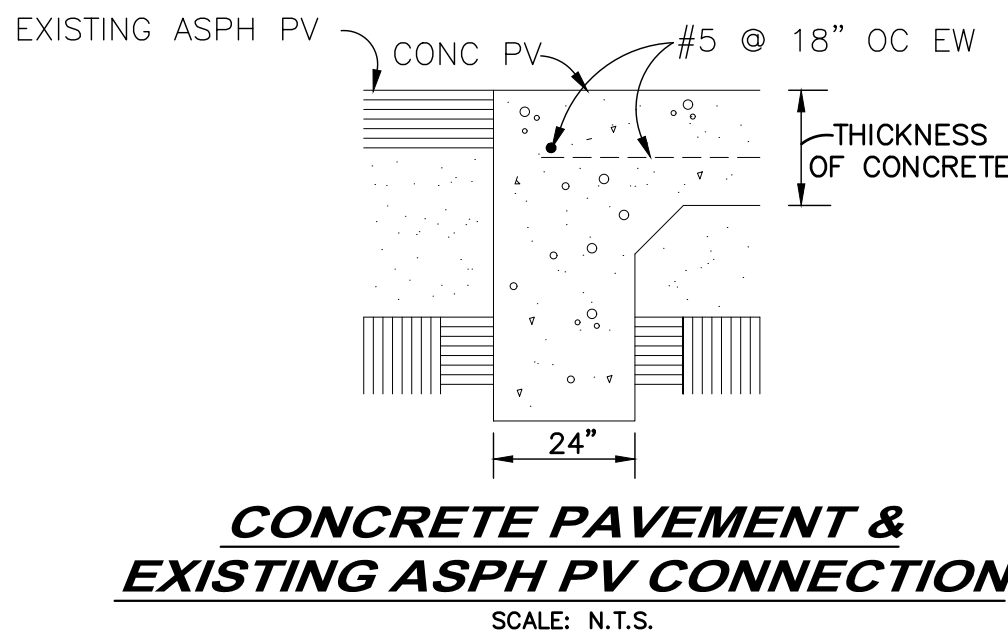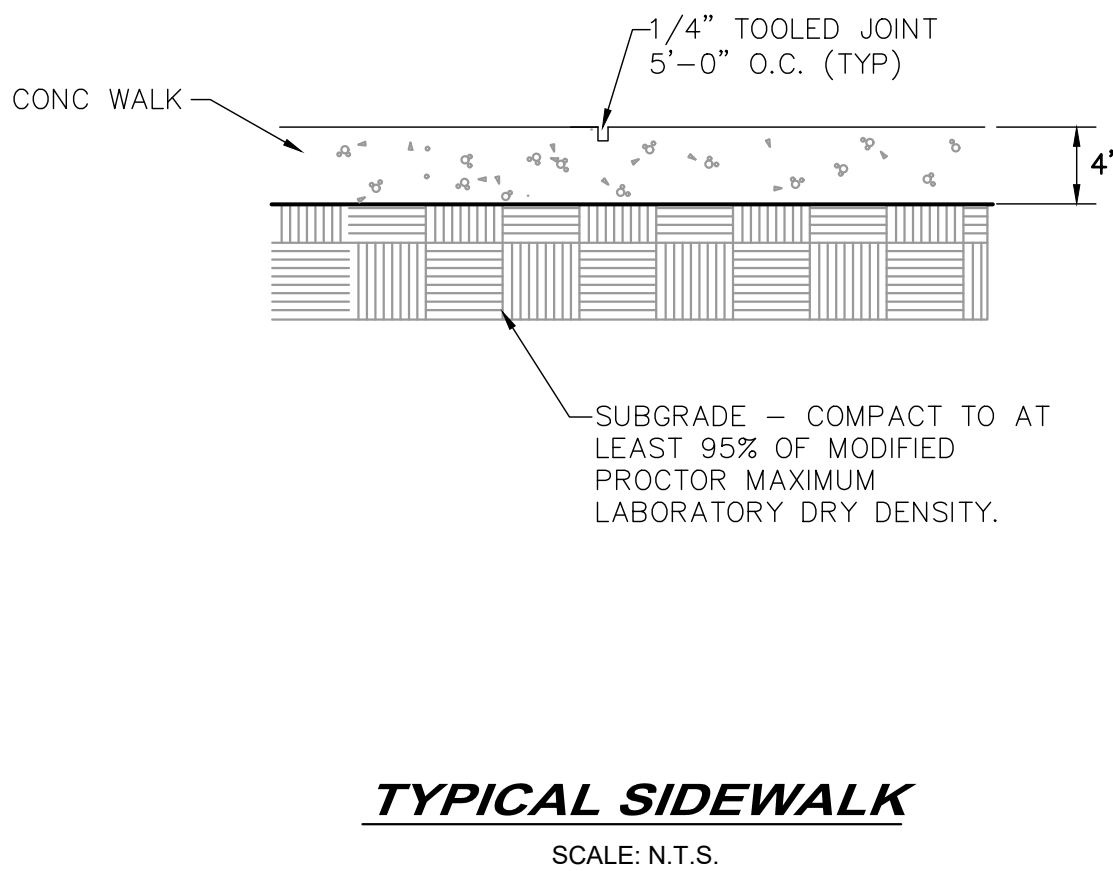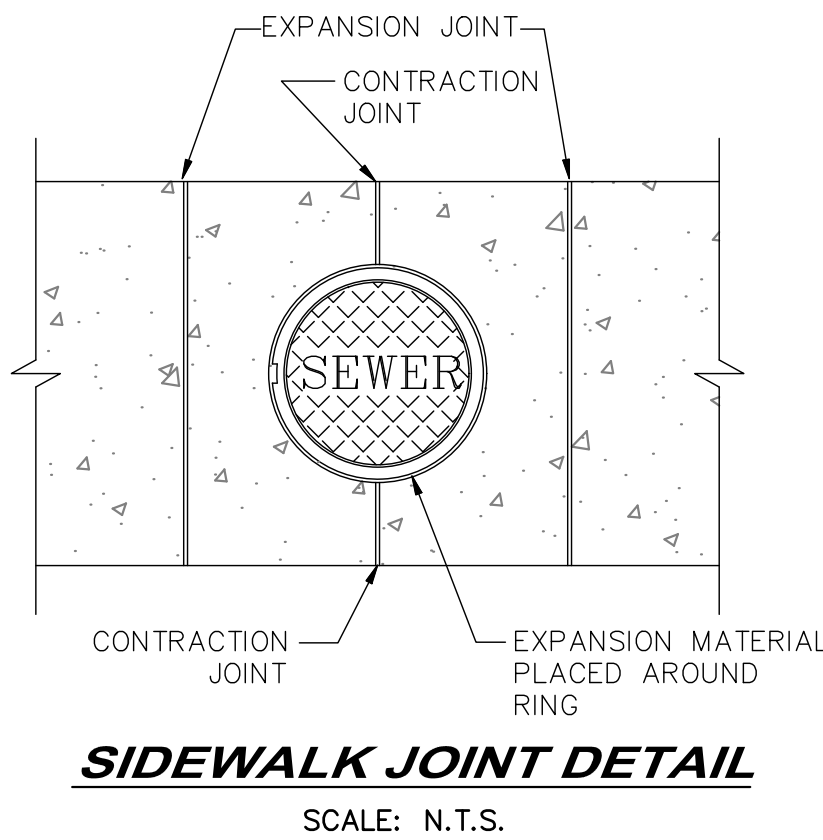

CLARK'S FERRY SUBDIVISION



HOO SHOO TOO RD.

BATON ROUGE


EAST BATON ROUGE PARISH

TYPICAL SECTION & DETAILS


DESIGNED	CHECKED	DATE	BY	REVISION	DESCRIPTION
JOB	JOB	JOB	JOB	JOB	JOB
CMS	CMS	CMS	CMS	CMS	CMS
12/2018	2	OF 17			
SHEET	NUMBER	2			

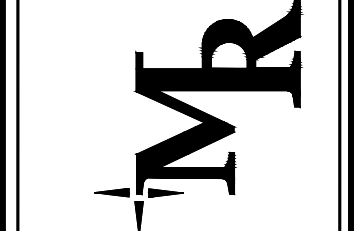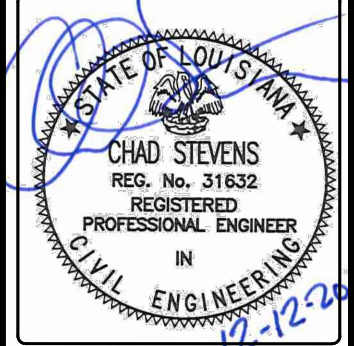



MR ENGINEERING & SURVEYING, LLC
9345 Interline Avenue, Baton Rouge, LA 70809 225.490.9592

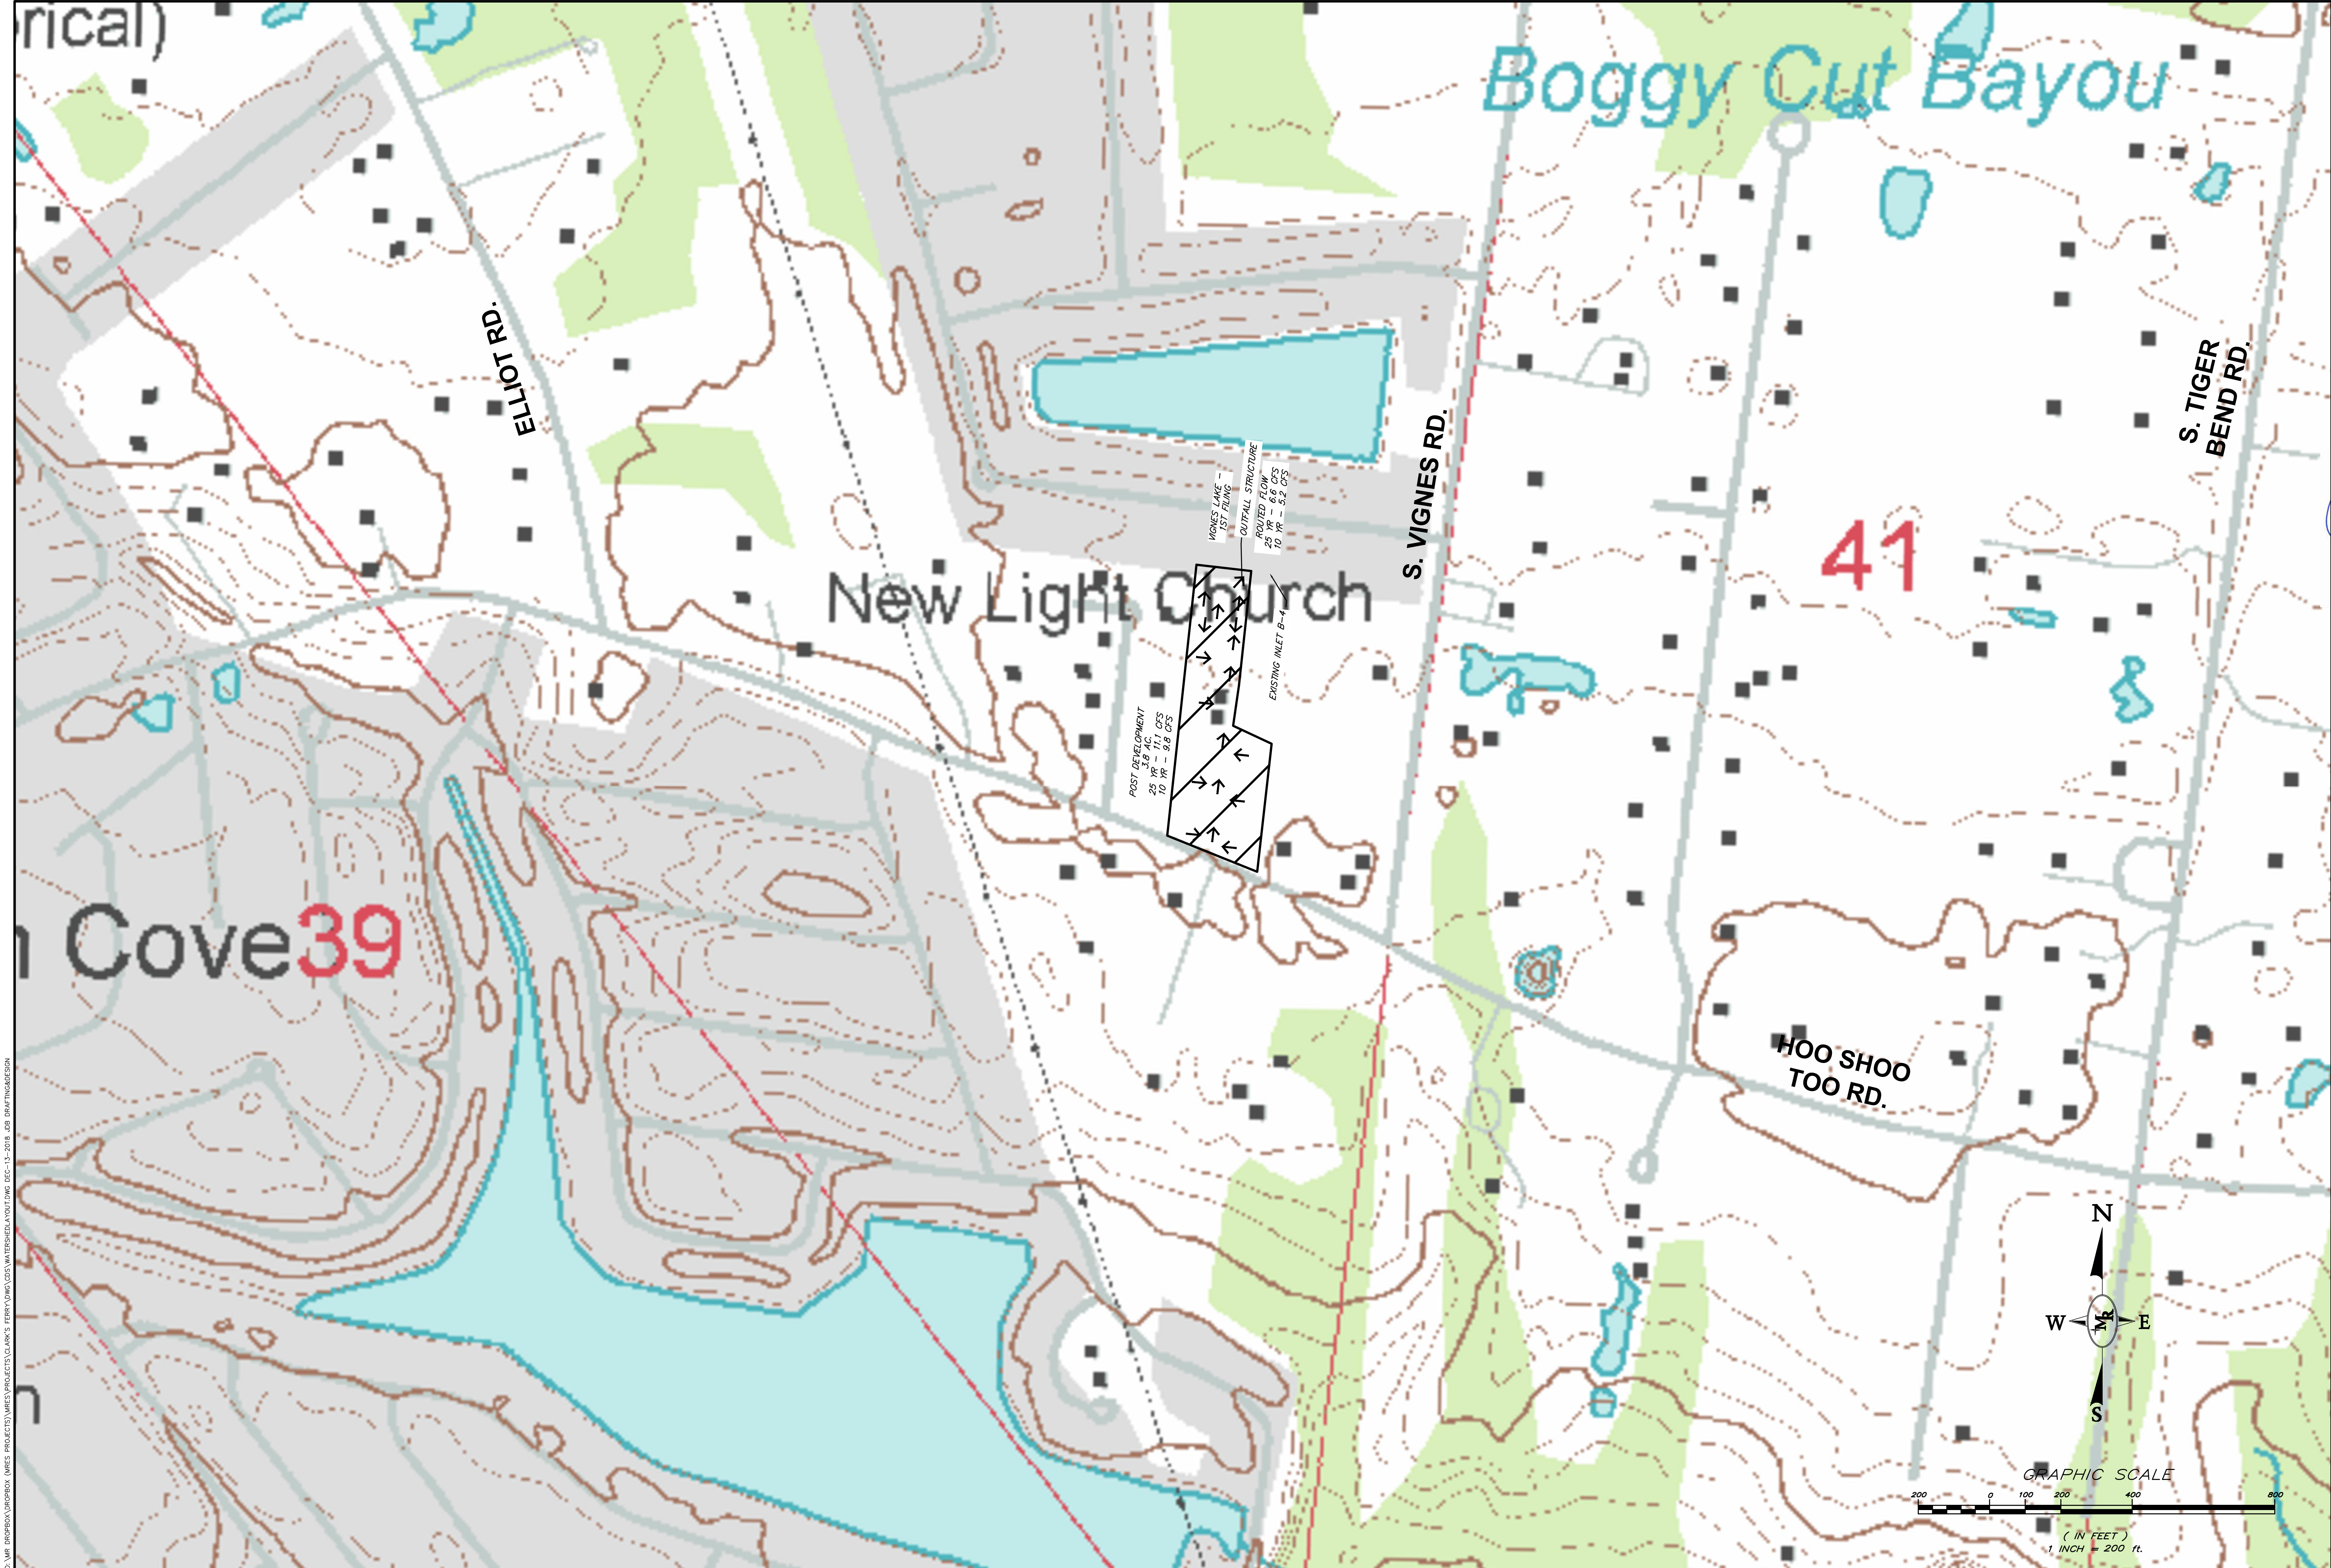

C:\MR_DROPBOX\GORDON\WORKS\PROJECTS\CLARK'S FERRY\OWAS\WATERSHED\A\TOWING DEC-13-2018 JOB DRAFTING\DESIGN

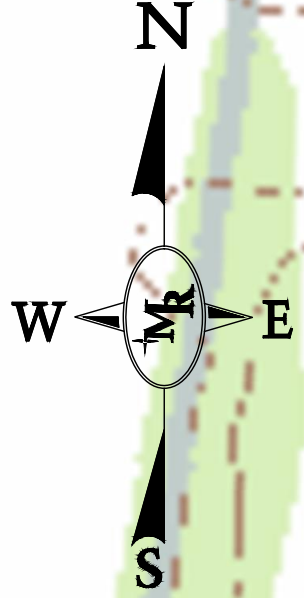

CLARK'S FERRY SUBDIVISION HOO SHOO TOO RD. BATON ROUGE EAST BATON ROUGE PARISH WATERSHED LAYOUT		DESIGNED CHECKED OAS		JOB OAS		DATE 12/2018		BY 3 OF 17	
REVISION DATE		REVISION DESCRIPTION		BY		SHEET NUMBER		3	
MR ENGINEERING & SURVEYING, LLC 9345 Interline Avenue, Baton Rouge, LA 70809 225.490.9592		CHAD STEVENS REG. No. 31632 REGISTERED PROFESSIONAL ENGINEER IN ENGINEERING		MR ENGINEERING & SURVEYING, LLC		9345 Interline Avenue, Baton Rouge, LA 70809 225.490.9592			

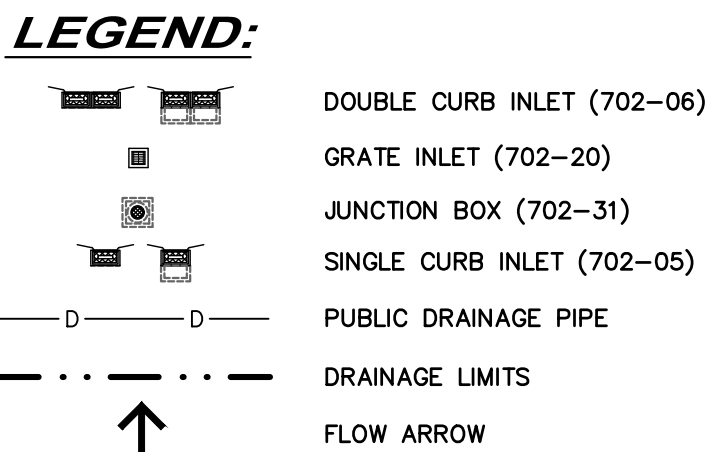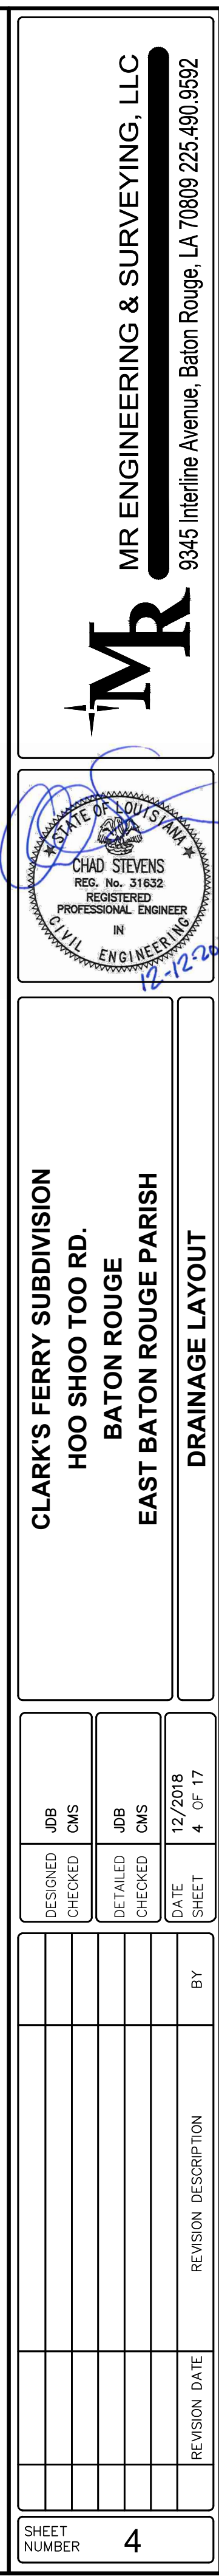



NOTES:

1. EMBANKMENT WHERE REQUIRED, SHALL BE PLACED IN 8" LOOSE LIFTS AND COMPACTED TO 95% MAXIMUM DENSITY AT OPTIMUM MOISTURE AS DETERMINED BY STANDARD PROCTOR TEST. ALL COSTS FOR EMBANKMENT CONSTRUCTION SHALL BE INCLUDED IN PAY ITEM FOR SAME.
2. BEFORE STARTING ANY EMBANKMENT CONSTRUCTION, REMOVE ALL VEGETATIVE MATTER AND THOROUGHLY SCARIFY AREA TO A MINIMUM DEPTH OF 6" AND RECOMPACT TO 95% MAXIMUM DENSITY AT OPTIMUM MOISTURE (NO DIRECT PAY).
3. THE CONTRACTOR SHALL BE RESPONSIBLE FOR DETERMINING THE EXACT LOCATION, DEPTH, AND SIZE OF ALL UNDERGROUND UTILITIES AND STRUCTURES AND SHALL BE LIABLE FOR ANY DAMAGE CAUSED BY THE FAILURE TO COMPLY WITH THESE INSTRUCTIONS.
4. ALL EXCESS EXCAVATION AND FILL MATERIAL IS TO BE PLACED AND GRADED AS DIRECTED BY THE PROJECT ENGINEER. THE MATERIAL SHALL BE REASONABLY FREE OF DEBRIS OR OTHER DETRIMENTAL MATERIAL, AND SHALL HAVE REASONABLE MOISTURE CONTENT WHEN PLACED. ALL FILL SHALL BE PLACED IN LAYERS AND COMPACTED TO AT LEAST 93% OF THE MAXIMUM DENSITY AS DETERMINED BY THE STANDARD PROCTOR (ASTM D-698) TEST. (NO DIRECT PAY)
5. BASE FLOOD ELEVATION: 26.0'
INUNDATION ELEVATION: 25.5'
10-YEAR DESIGN WATER SURFACE: 25.17'
6. EXISTING DRAINAGE PATTERNS ON-SITE SHALL BE MAINTAINED DURING CONSTRUCTION UNTIL SUCH TIME THAT THE INSTALLED DRAINAGE CAN ADEQUATELY CONVEY THE RUNOFF TO THE PROPOSED OUTFALL.
7. THE PONDS SHALL BE PRIVATELY OWNED & MAINTAINED BY THE CLARK'S FERRY SUBDIVISION HOMEOWNERS ASSOCIATION. THE CITY CUSH DOES NOT OWN OR MAINTAIN PRIVATE PONDS. THIS NOTE SHALL BE REQUIRED ON THE FINAL PLAN.


ALL LOTS SHALL HAVE PRIVATE 12" YARD INLETS EXCEPT WHERE CITY-PARISH GRATE INLET IS PRESENT ON PROPERTY LINE. THIS INCLUDES LOTS 2-4, 9, 10, 13 & 14.

AS PART OF THE HOUSE CONSTRUCTION, IT SHALL BE THE RESPONSIBILITY OF THE LAND OWNER OR HIS REPRESENTATIVE TO GRADE EACH LOT SO THAT THE STORM DRAINAGE RUNOFF CONFORMS TO THIS APPROVED DRAINAGE LAYOUT UNLESS OTHERWISE APPROVED BY THE DEPARTMENT OF PUBLIC WORKS.


D:\MR_DROPBOX\OROBROX (MR)S PROJECTS\CLARK'S FERRY\DWG\SEWER\SEWERLAYOUT.DWG DEC-13-2018 1:08 DRAFTING\DESIGN

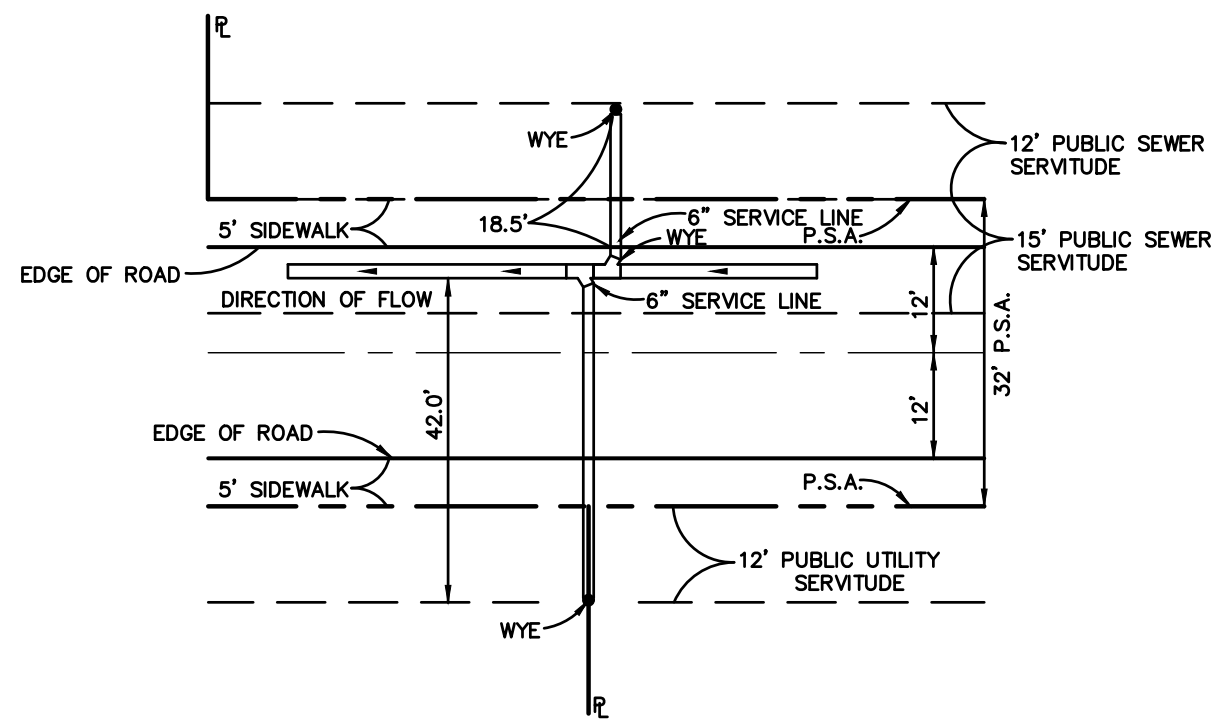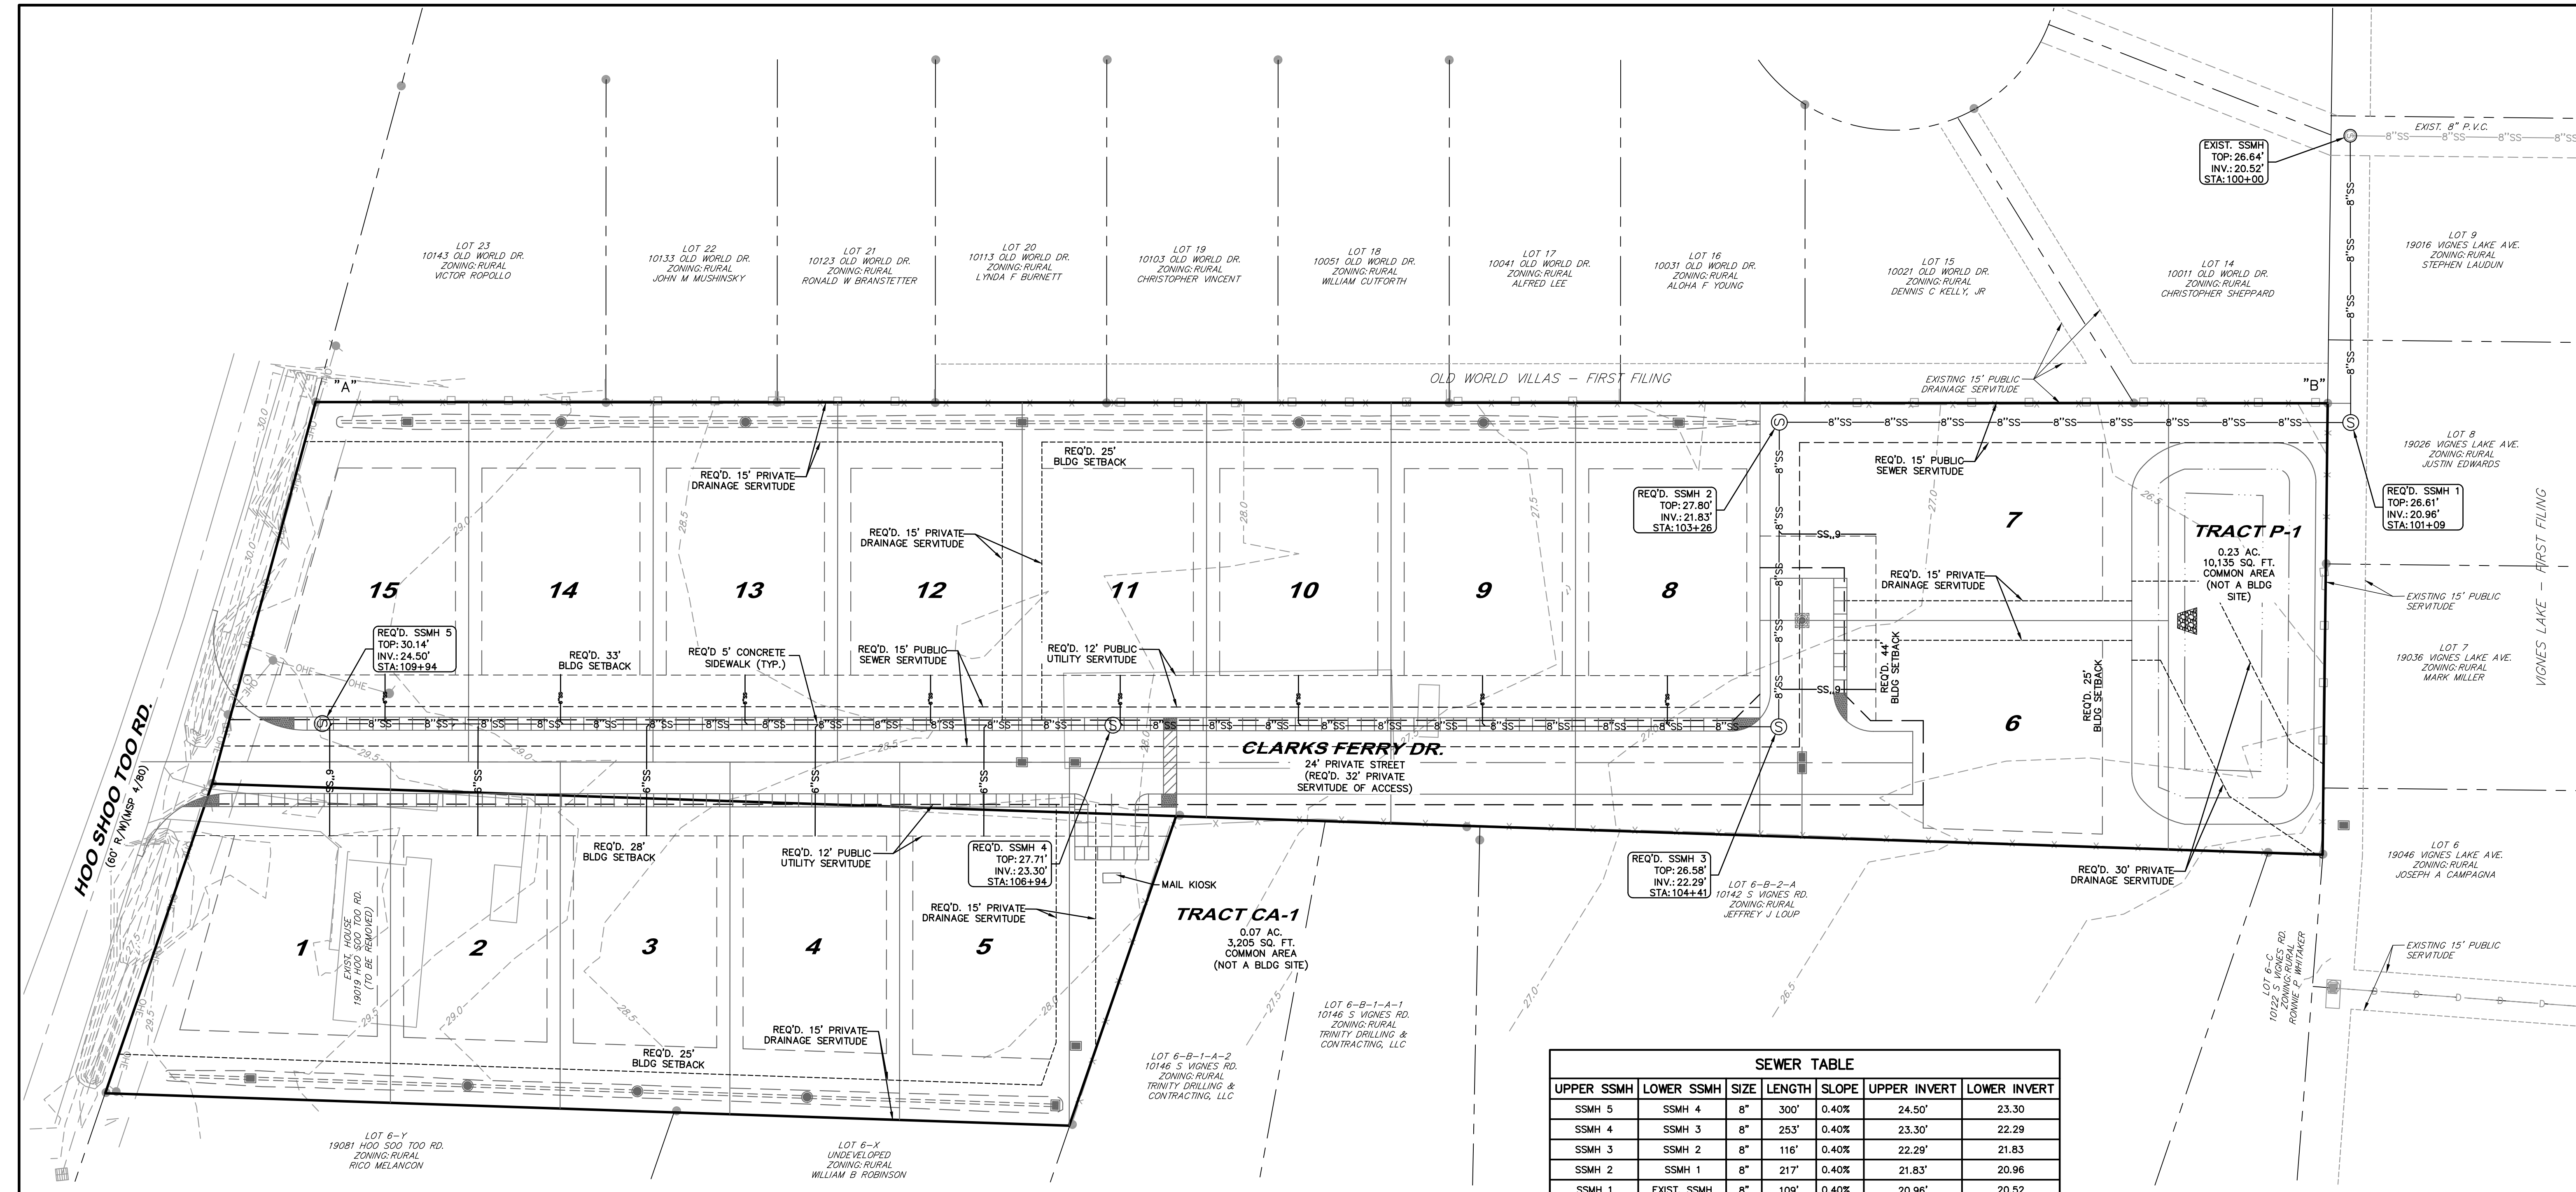

PROPOSED SEWER SERVICE DETAIL
SCALE: N.T.S.

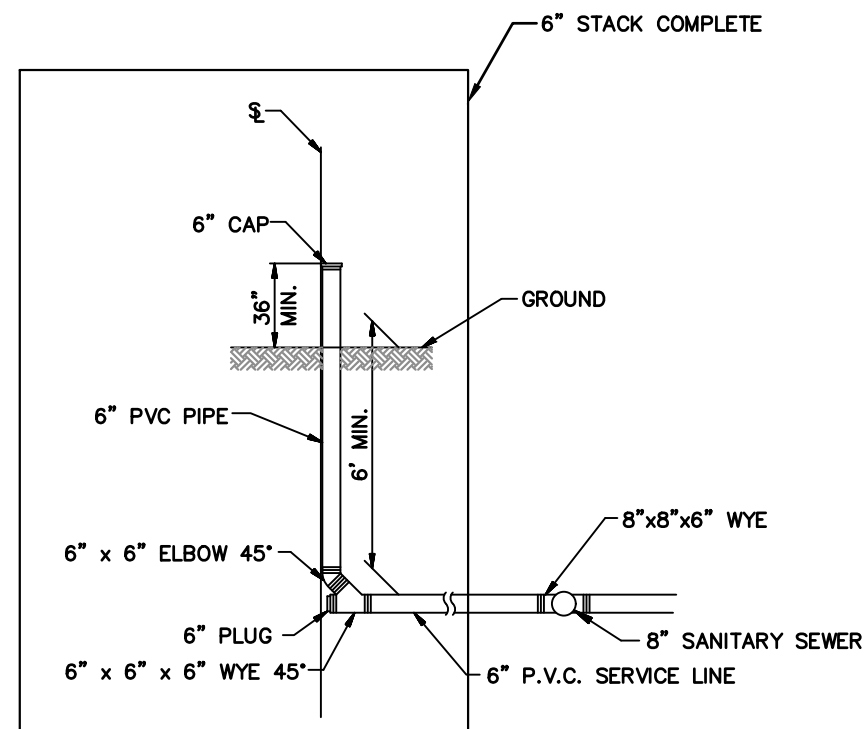

DETAIL 'A'
SCALE: N.T.S.

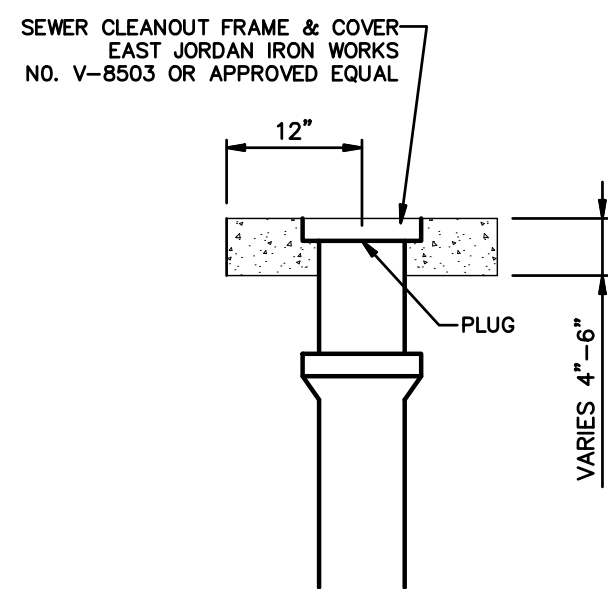

DETAIL 'B'
SCALE: N.T.S.


SEWER TABLE						
UPPER SSMH	LOWER SSMH	SIZE	LENGTH	SLOPE	UPPER INVERT	LOWER INVERT
SSMH 5	SSMH 4	8"	300'	0.40%	24.50'	23.30
SSMH 4	SSMH 3	8"	253'	0.40%	23.30'	22.29
SSMH 3	SSMH 2	8"	116'	0.40%	22.29'	21.83
SSMH 2	SSMH 1	8"	217'	0.40%	21.83'	20.96
SSMH 1	EXIST. SSMH	8"	109'	0.40%	20.96'	20.52

NOTES:

- MINIMUM DEPTH OF HOUSE CONNECTIONS AT THE PROPERTY LINE SHALL BE 4 TO 6 FEET BELOW THE NATURAL GROUND AT THE P/W LINE. HOUSE CONNECTIONS FROM THE MAIN SEWER TO THE PROPERTY SHALL HAVE A MINIMUM SLOPE OF 1% AND 2% WHERE AVAILABLE DEPTH PERMITS. SERVICE LINES IN SERVITUDES MUST BE EXTENDED TO THE EDGE OF THE SERVITUDE. FOR INDIVIDUAL SANITARY SEWER SERVICE LINES THAT CANNOT DRAIN BY GRAVITY TO THE SANITARY SEWER COLLECTION SYSTEM, EITHER A LIFT STATION SHALL BE REQUIRED FOR THAT LOT OR A NOTE SHALL BE REQUIRED ON THE FINAL PLAT WHICH ADVISES THE FUTURE LOT OWNER.
- SEWER MAINS SHALL BE LAID AT LEAST 6 FEET, MEASURED FROM EDGE TO EDGE, FROM EXISTING OR PROPOSED WATER MAIN. SEWER MAINS CROSSING WATER MAINS SHALL BE LAID TO PROVIDE A MINIMUM VERTICAL DISTANCE OF 18 INCHES BETWEEN THE OUTSIDE OF THE WATER MAIN AND THE OUTSIDE OF THE SEWER.
- ALL PVC GRAVITY SEWER PIPE SHALL HAVE A MINIMUM SDR OF 35 & SHALL COMPLY WITH ASTM D 3034. JOINTS SHALL BE RUBBER GASKET BALL & SPIGOT OR COUPLING TYPE JOINTS.
- ALL PVC FORCE MAIN SEWER PIPE SHALL BE AWWA C 900, SDR 18, CLASS 150. JOINTS SHALL BE RUBBER GASKETED INTEGRAL BELL AND SPIGOT JOINTS OR DOUBLE BELL COUPLING WITH PLAIN END SPIGOTS.
- POST INSTALLATION TESTS FOR SEWER LINES AND MANHOLES SHALL INCLUDE A MANHOLE VACUUM TEST (VACUUM PRESSURE OF -5 PSIG APPLIED TO MANHOLE, ALLOWABLE DROP TO -4.5 PSIG IN ONE MINUTE), AN AIR PRESSURE TEST (IN ACCORDANCE WITH ASTM F 1417), A MANDREL TEST (MAXIMUM DEFLECTION 5%, TO BE TESTED AFTER PIPE HAS BEEN BACKFILLED 30 DAYS WITH A MANDREL SIZED 95% OF INSIDE PIPE DIAMETER PULLED BY HAND), AND A LAMP TEST (LIGHT SOURCE TO BE PLACED AT ONE END OF PIPE AND CIRCULAR SECTION SHALL BE VIEWED FROM OPPOSITE END).
- POST INSTALLATION TEST FOR FORCE MAIN PIPE SHALL INCLUDE A MANDREL TEST (MAXIMUM DEFLECTION 5%, TO BE TESTED AFTER PIPE HAS BEEN INSTALLED 30 DAYS).
- NO SURFACE WATER CROSSINGS EXIST ON THE PROJECT SITE.
- ALL PAY ITEMS FOR SANITARY SEWER MANHOLES AND SANITARY SEWER LINES USE DEPTHS CALCULATED FROM FINISHED GRADE TO INVERT OF PIPE/MANHOLE.
- NO WYES SHALL BE CONNECTED DIRECTLY TO A SEWER MANHOLE.

LEGEND:

- REQ'D. SEWER MANHOLE
- 8"SS— REQ'D. 8" SANITARY SEWER LINE
- 6"SS— REQ'D. 6" SANITARY SERVICE LINE

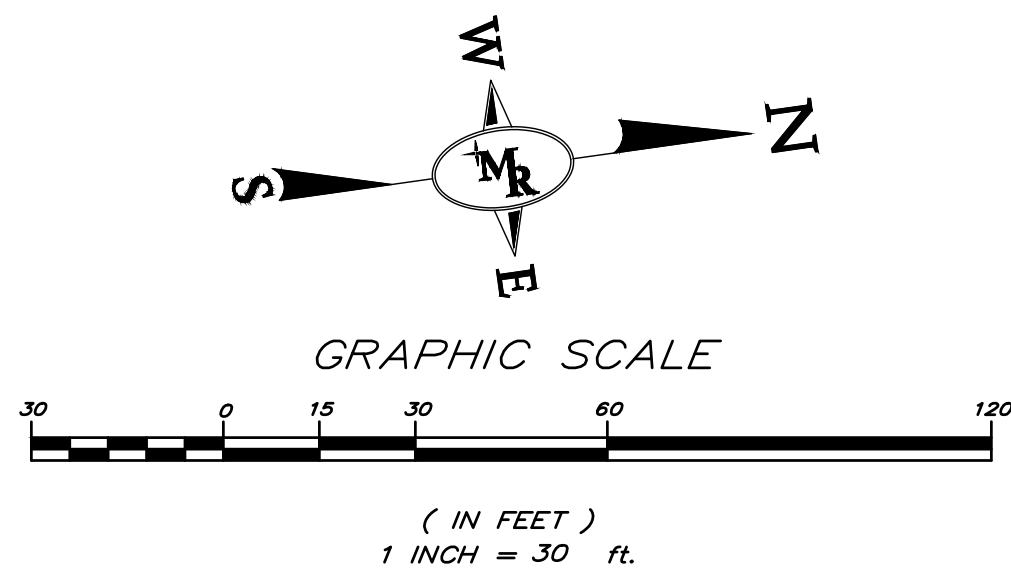

MR ENGINEERING & SURVEYING, LLC
9345 Interline Avenue, Baton Rouge, LA 70809 225.490.9592

12-2-2018



CLARK'S FERRY SUBDIVISION
HOO SHOO TOO RD.
BATON ROUGE
EAST BATON ROUGE PARISH
SEWER LAYOUT

DESIGNED	CHECKED	CMS	DATE	12/20/18	BY
DETAILED	CHECKED	CMS	SHEET	5 OF 17	

REVISION	DESCRIPTION
5	

SHEET NUMBER
5

D:\MR_DROPBOX\OROBROX (MRB PROJECTS)\MRB PROJECTS\CLARK'S FERRY\DWG\CLARKS FERRY\PLAN\PROJ.DWG DEC-13-2018 JOB DRAFTING\DESIGN

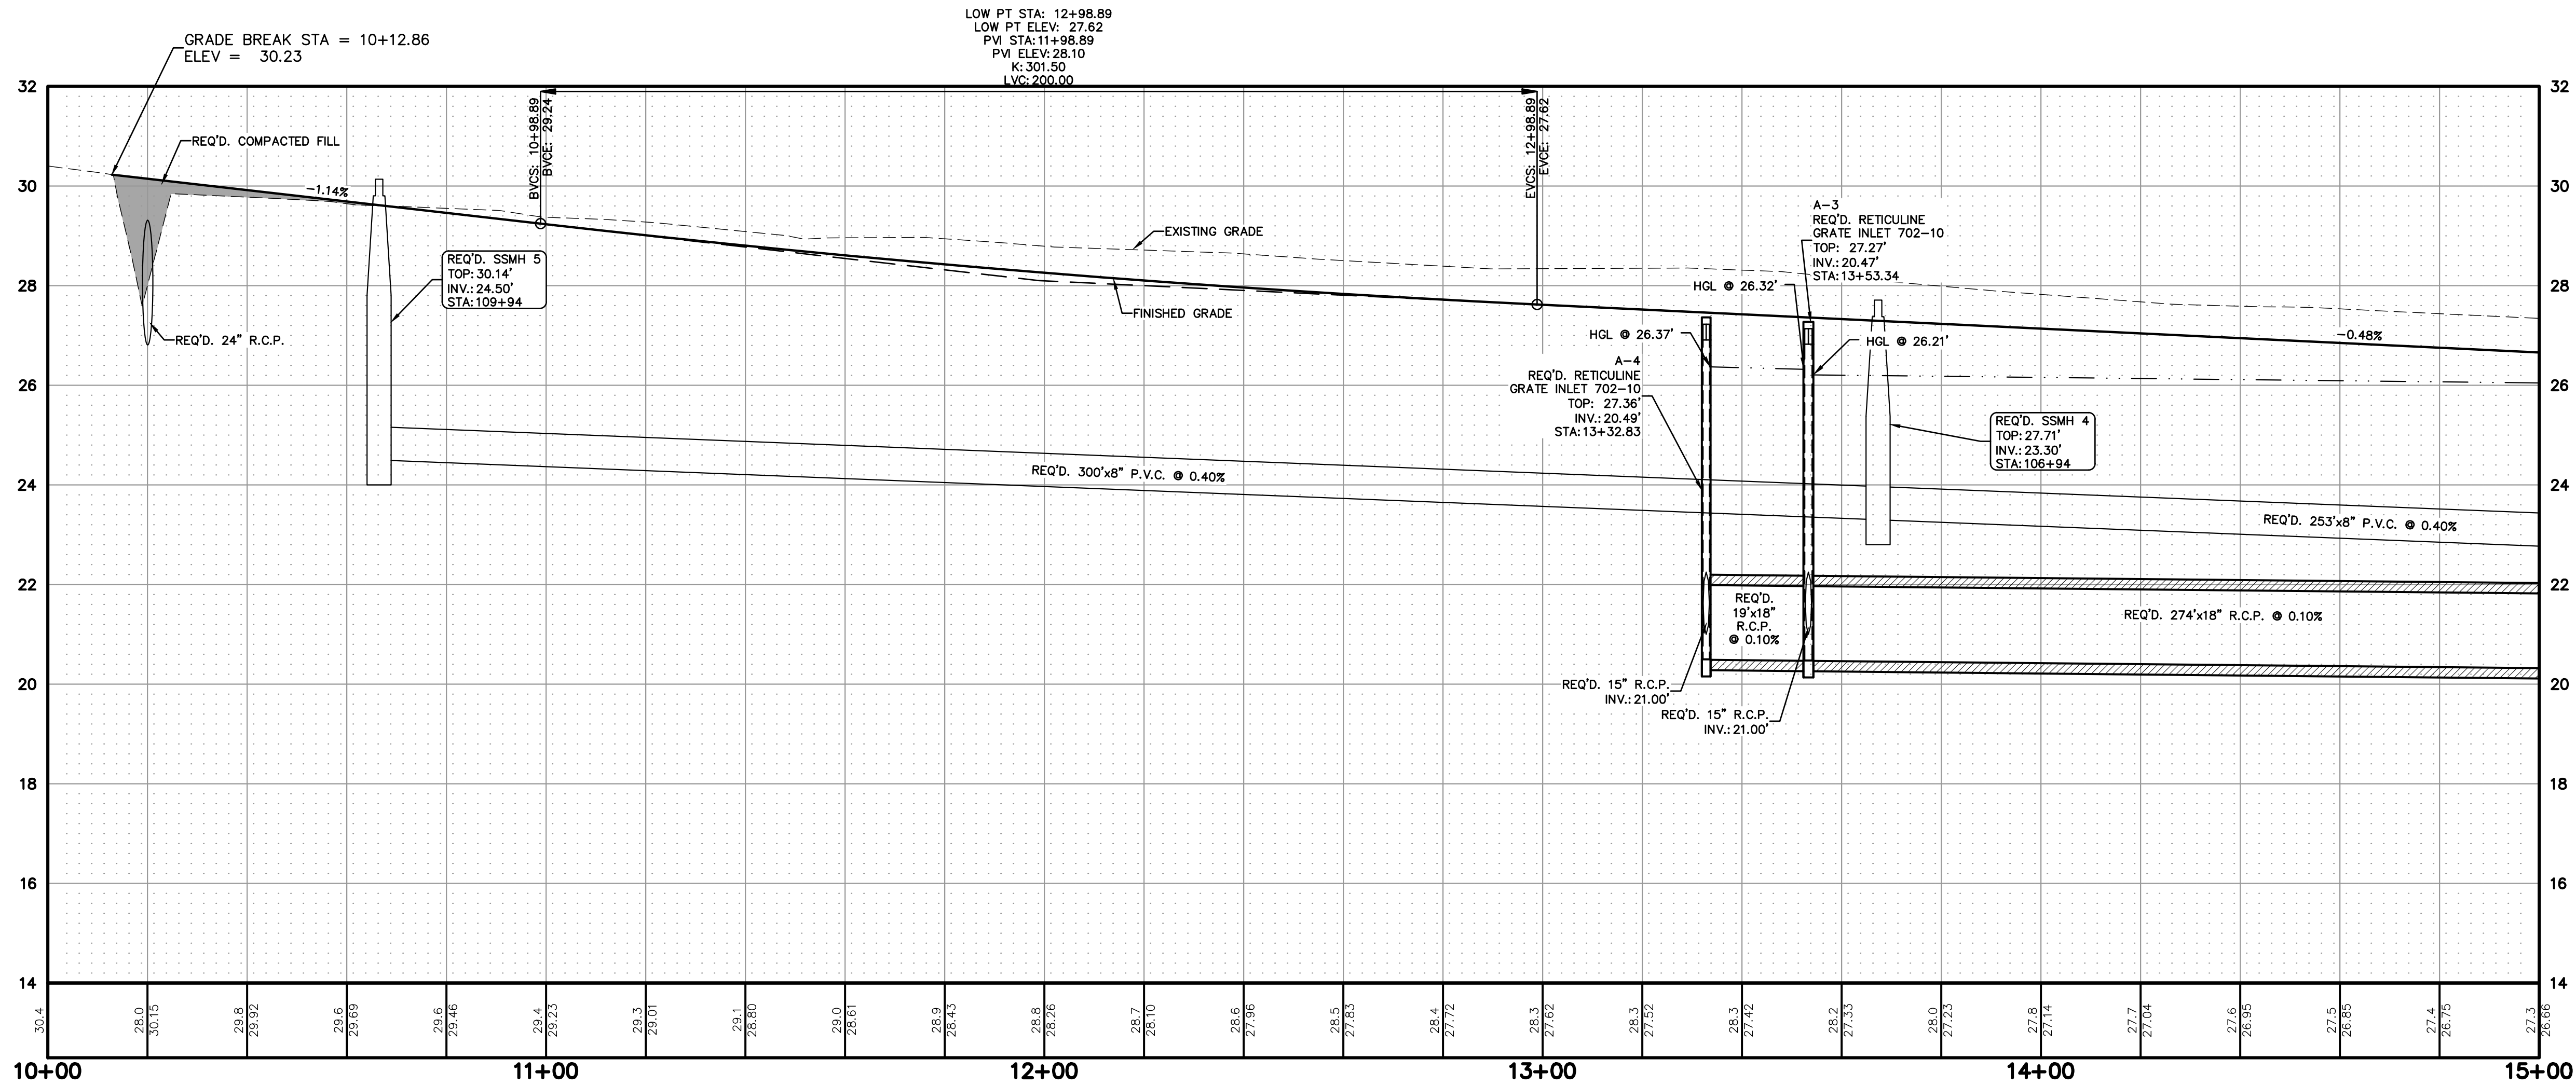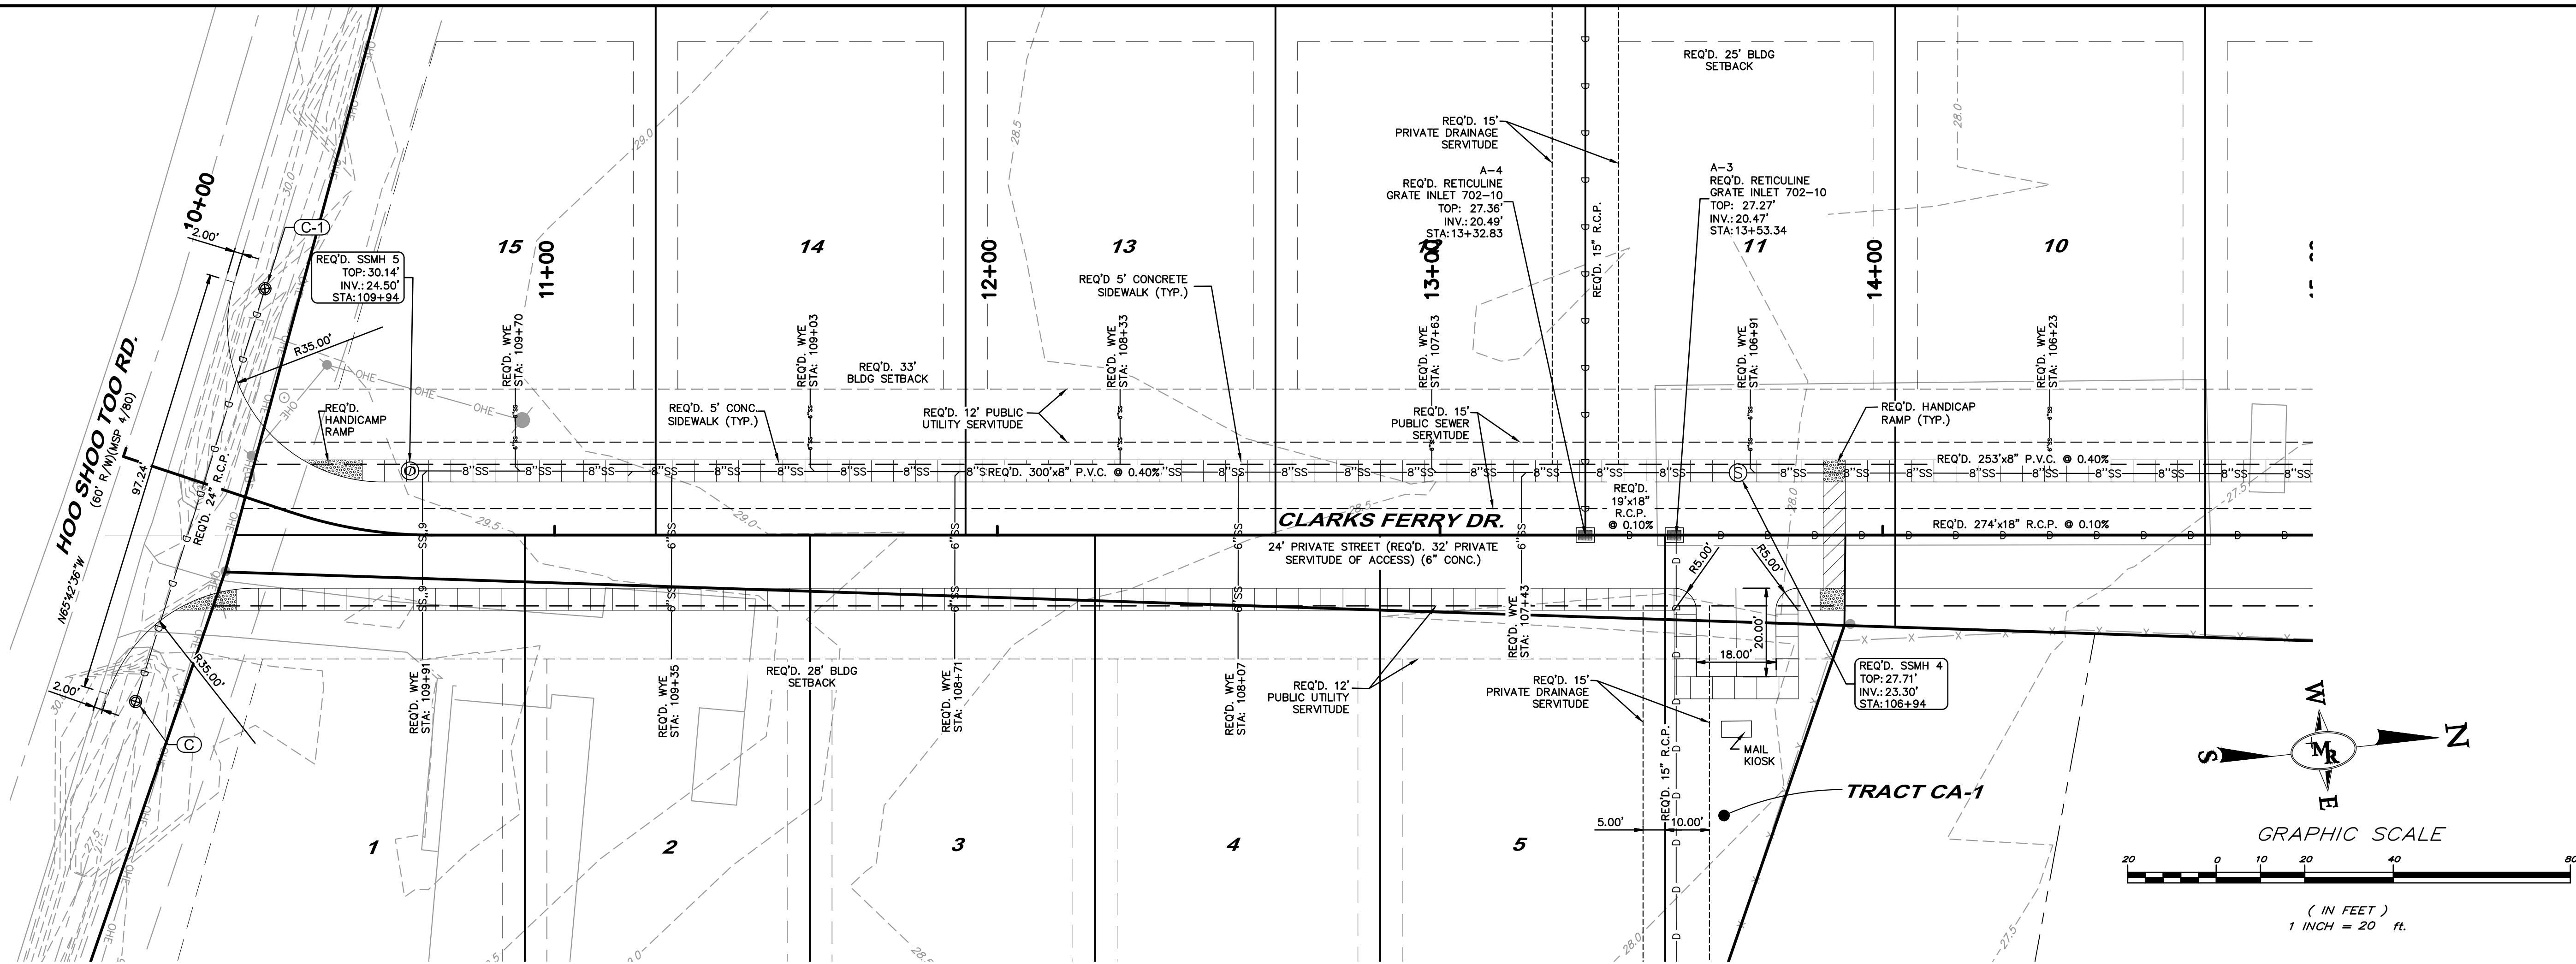

CLARK'S FERRY SUBDIVISION
HOO SHOO TOO RD.
BATON ROUGE
EAST BATON ROUGE PARISH
CLARK'S FERRY DR. PLAN & PROFILE

DESIGNED
CHECKED
CWS



DATE
12/20/18
SHEET
6 OF 17

BY




MR ENGINEERING & SURVEYING, LLC
9345 Interline Avenue, Baton Rouge, LA 70809 225.490.9592

CHAD STEVENS
REG. No. 31632
REGISTERED
PROFESSIONAL ENGINEER
IN
ENGINEERING



SHEET
NUMBER
6


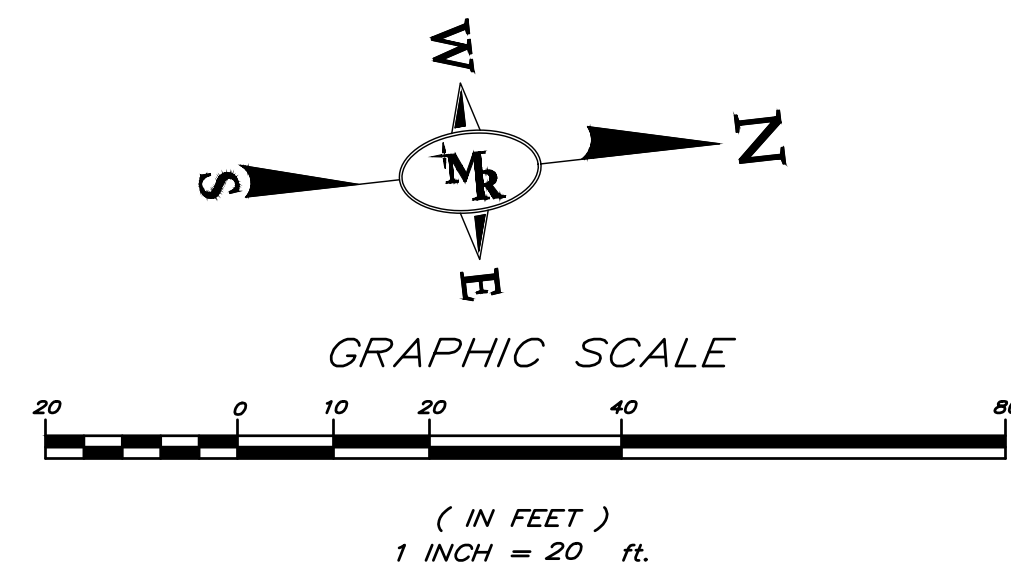
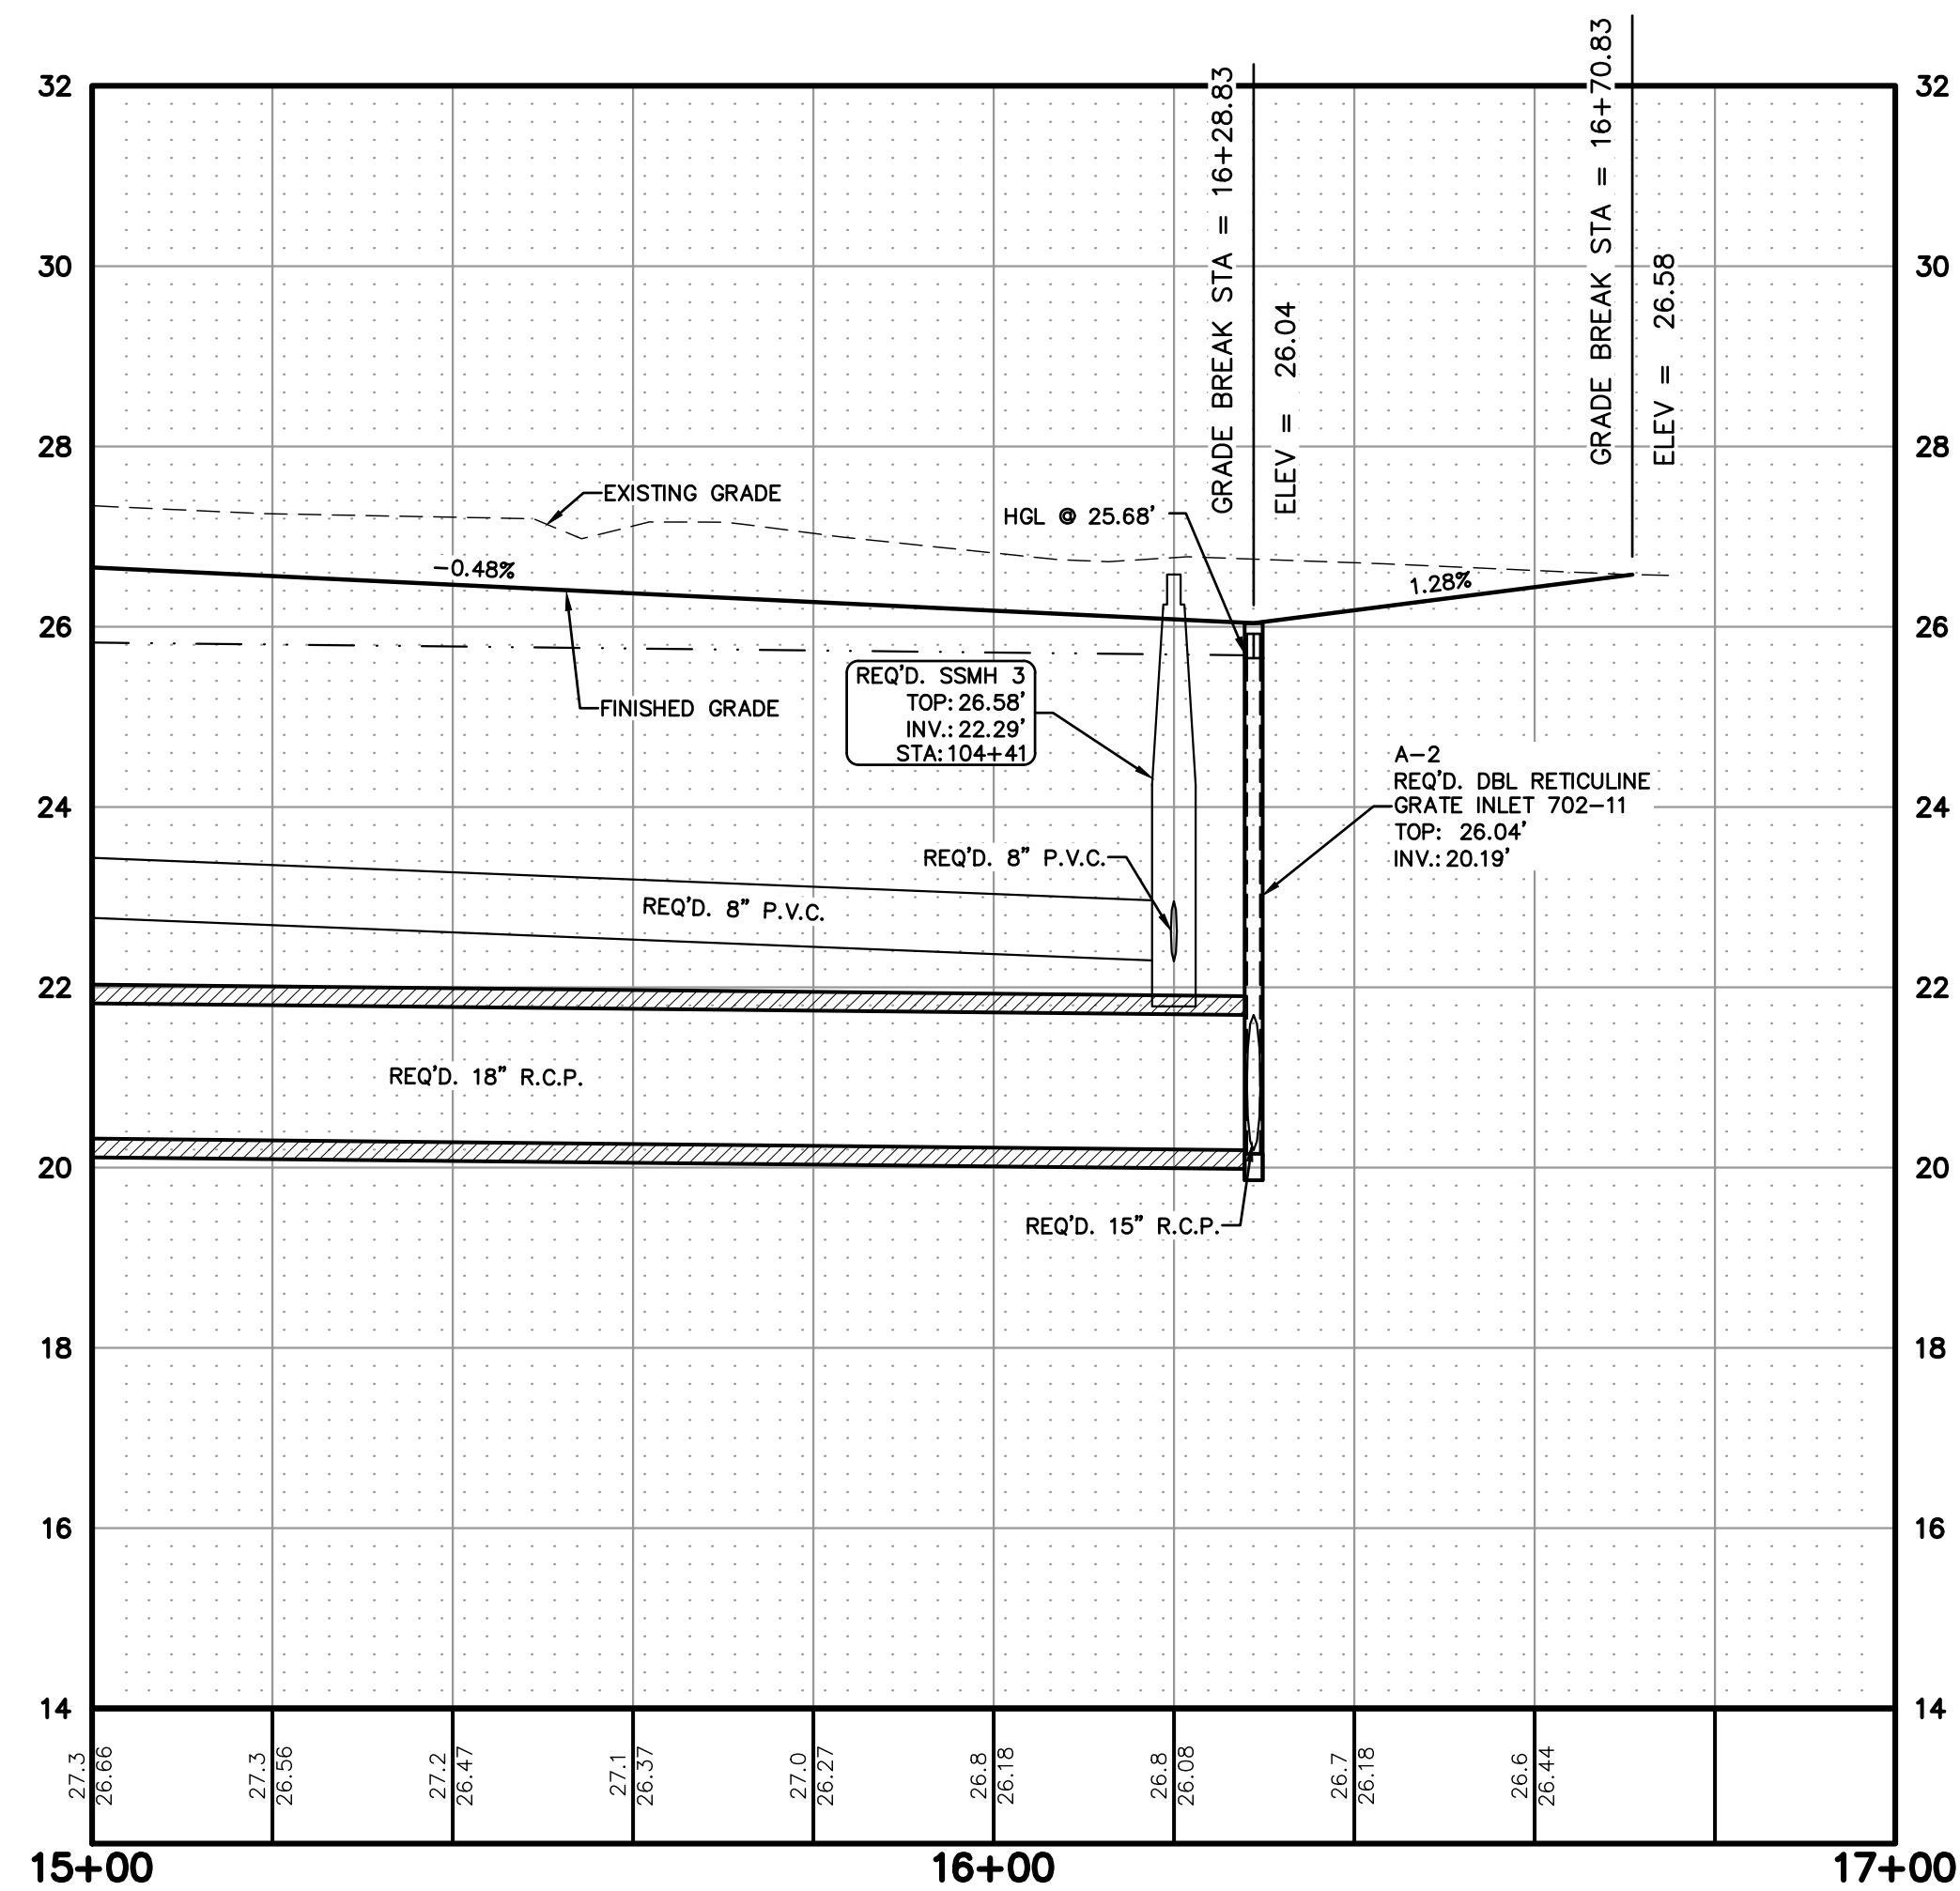




D:\MR DROPBOX\GROBOX (MRS PROJECTS)\MRS PROJECTS\CLARK'S FERRY\DWG\SS\OUTFALL\PRO.DWG DEC-13-2018 JOB DRAFTING\GSSON

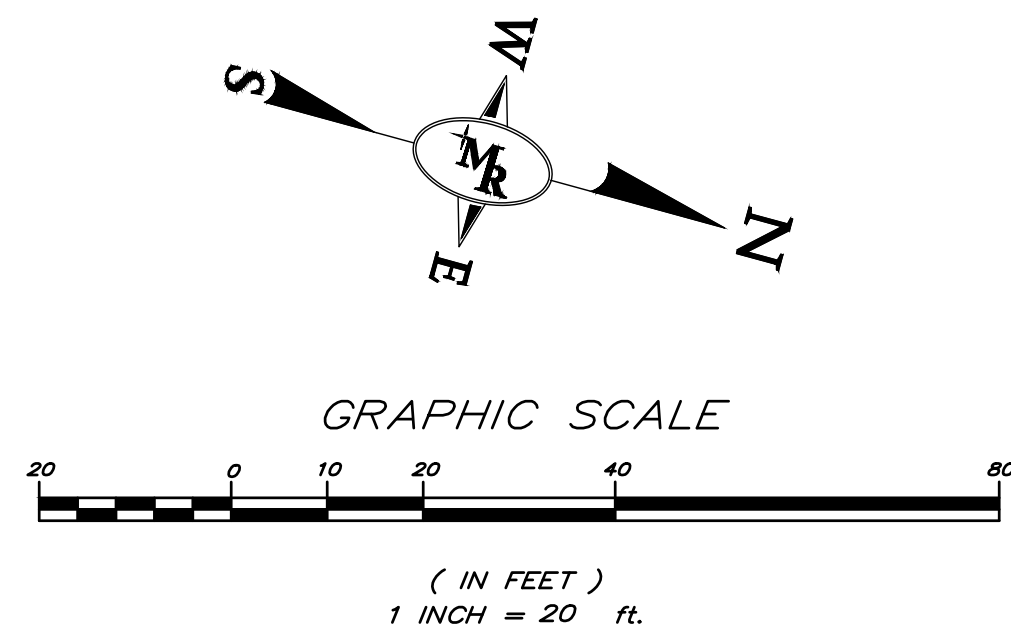
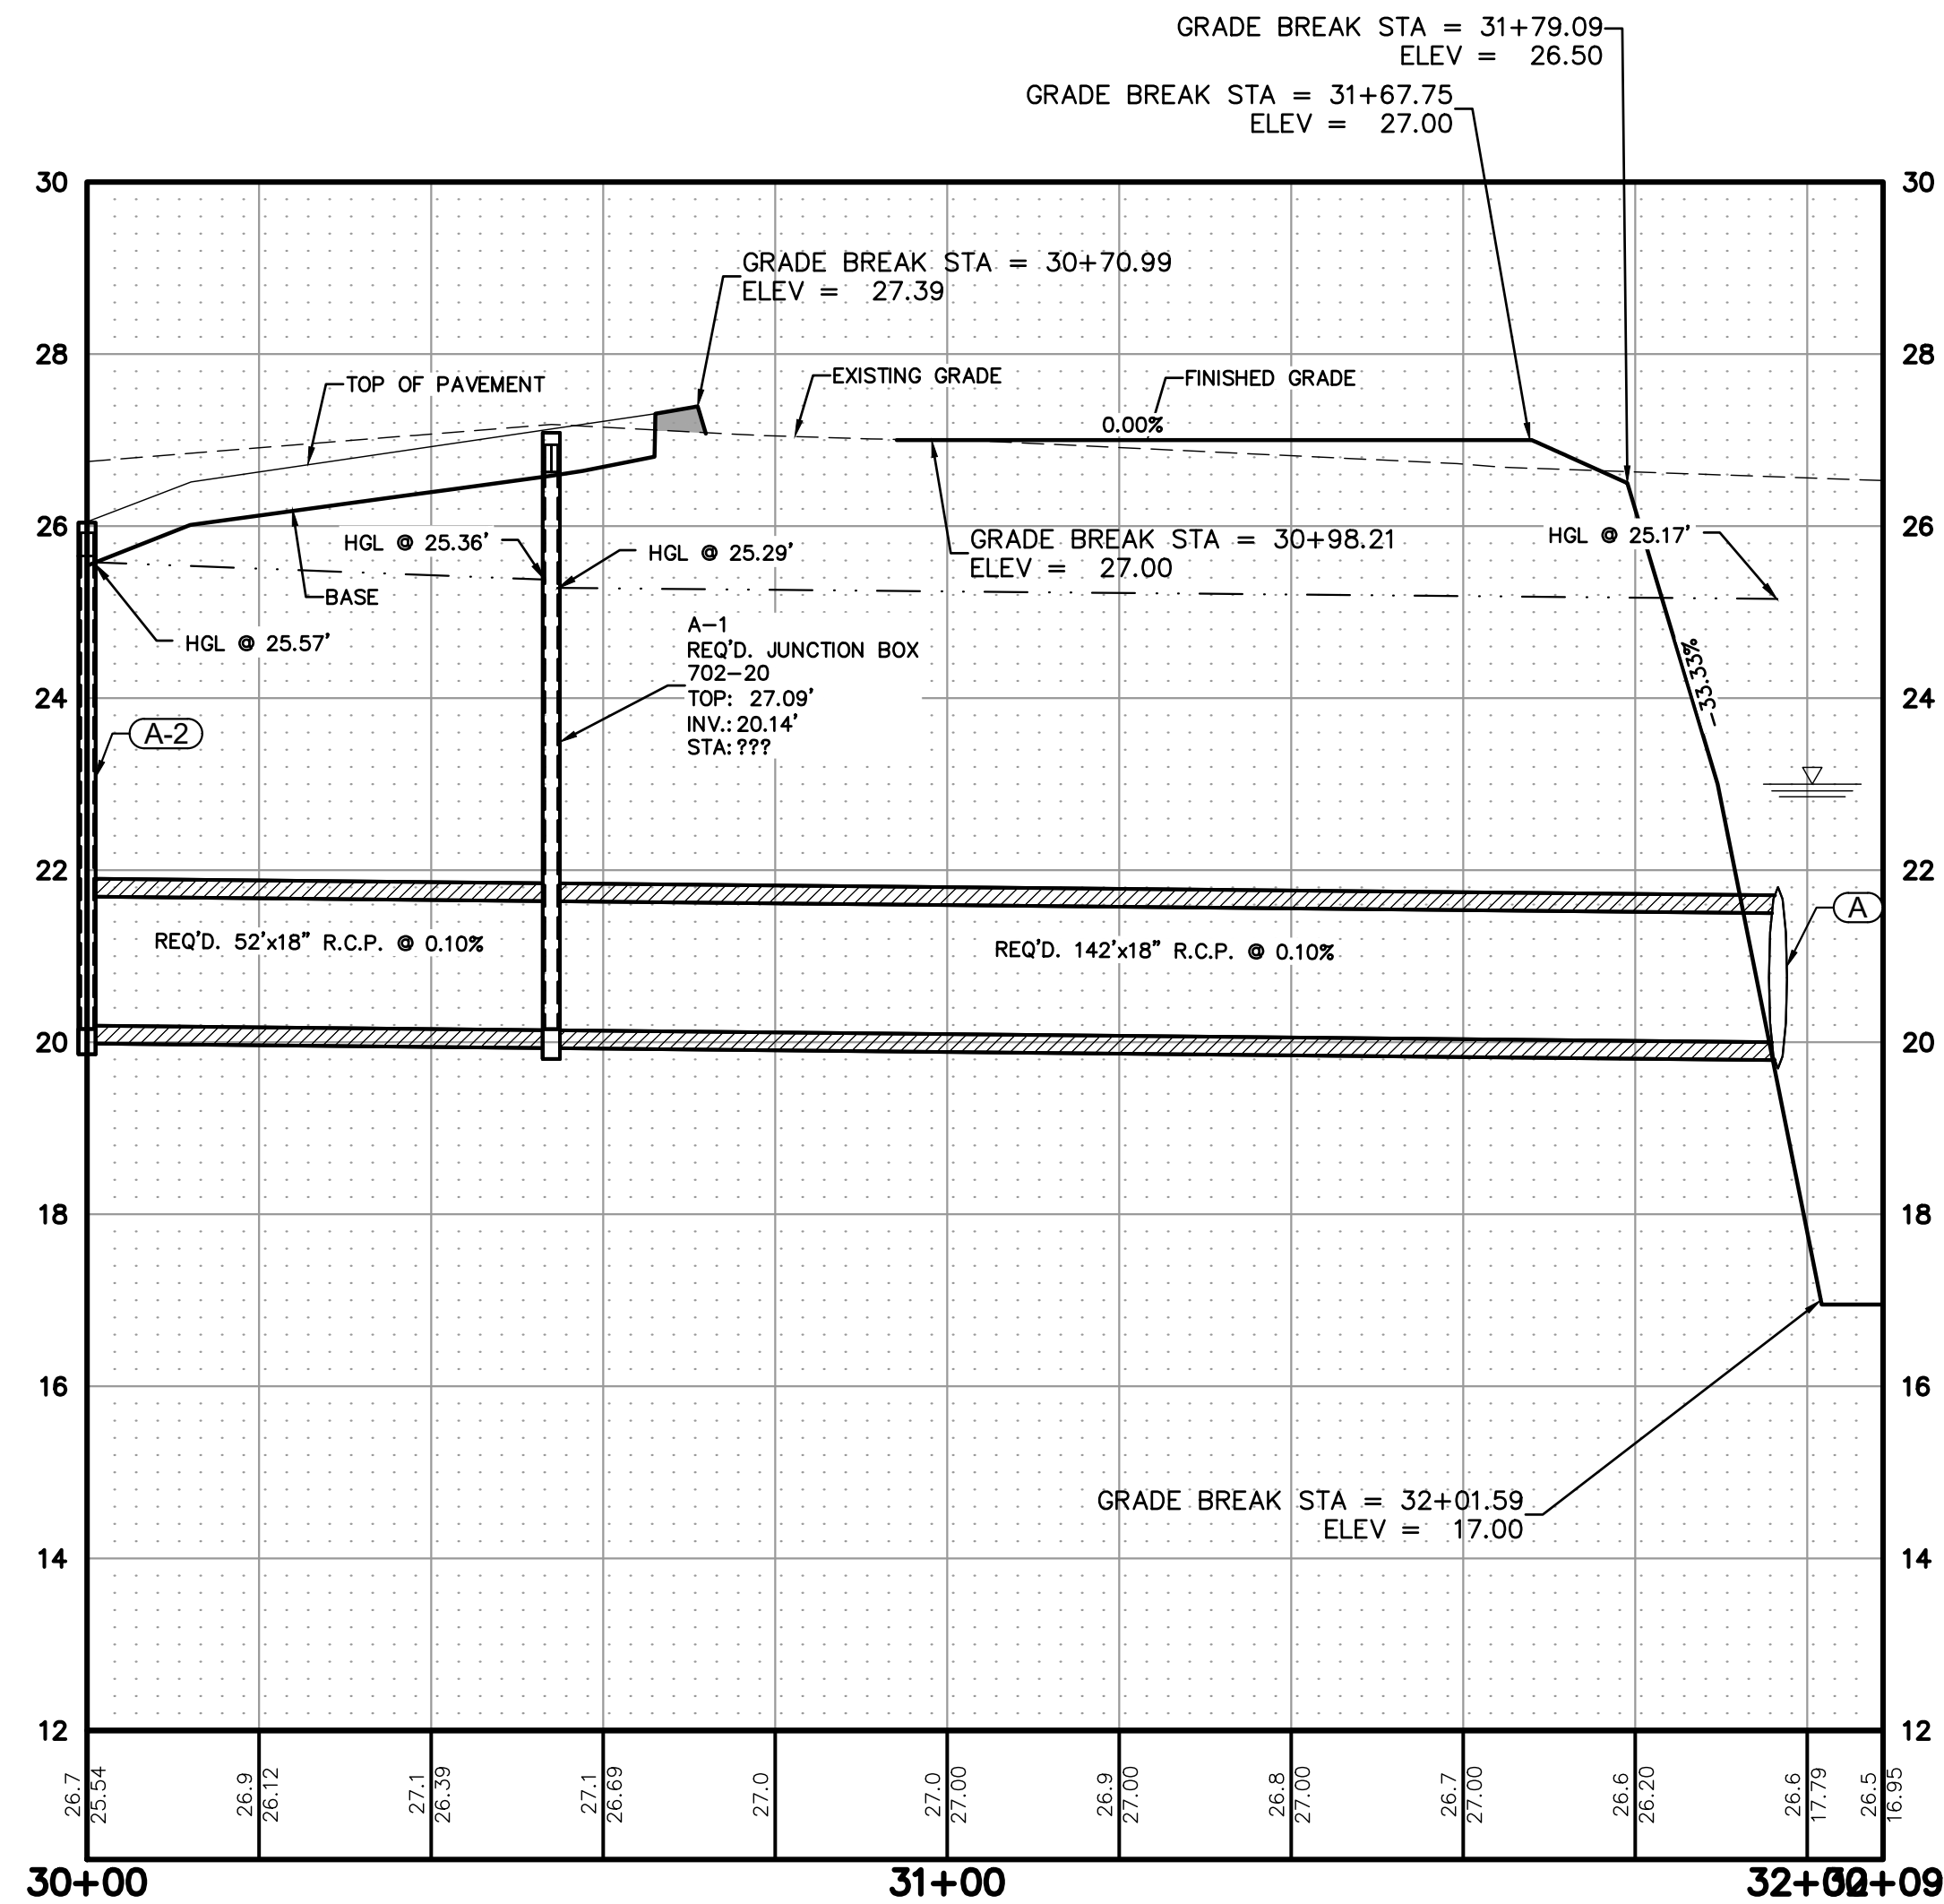
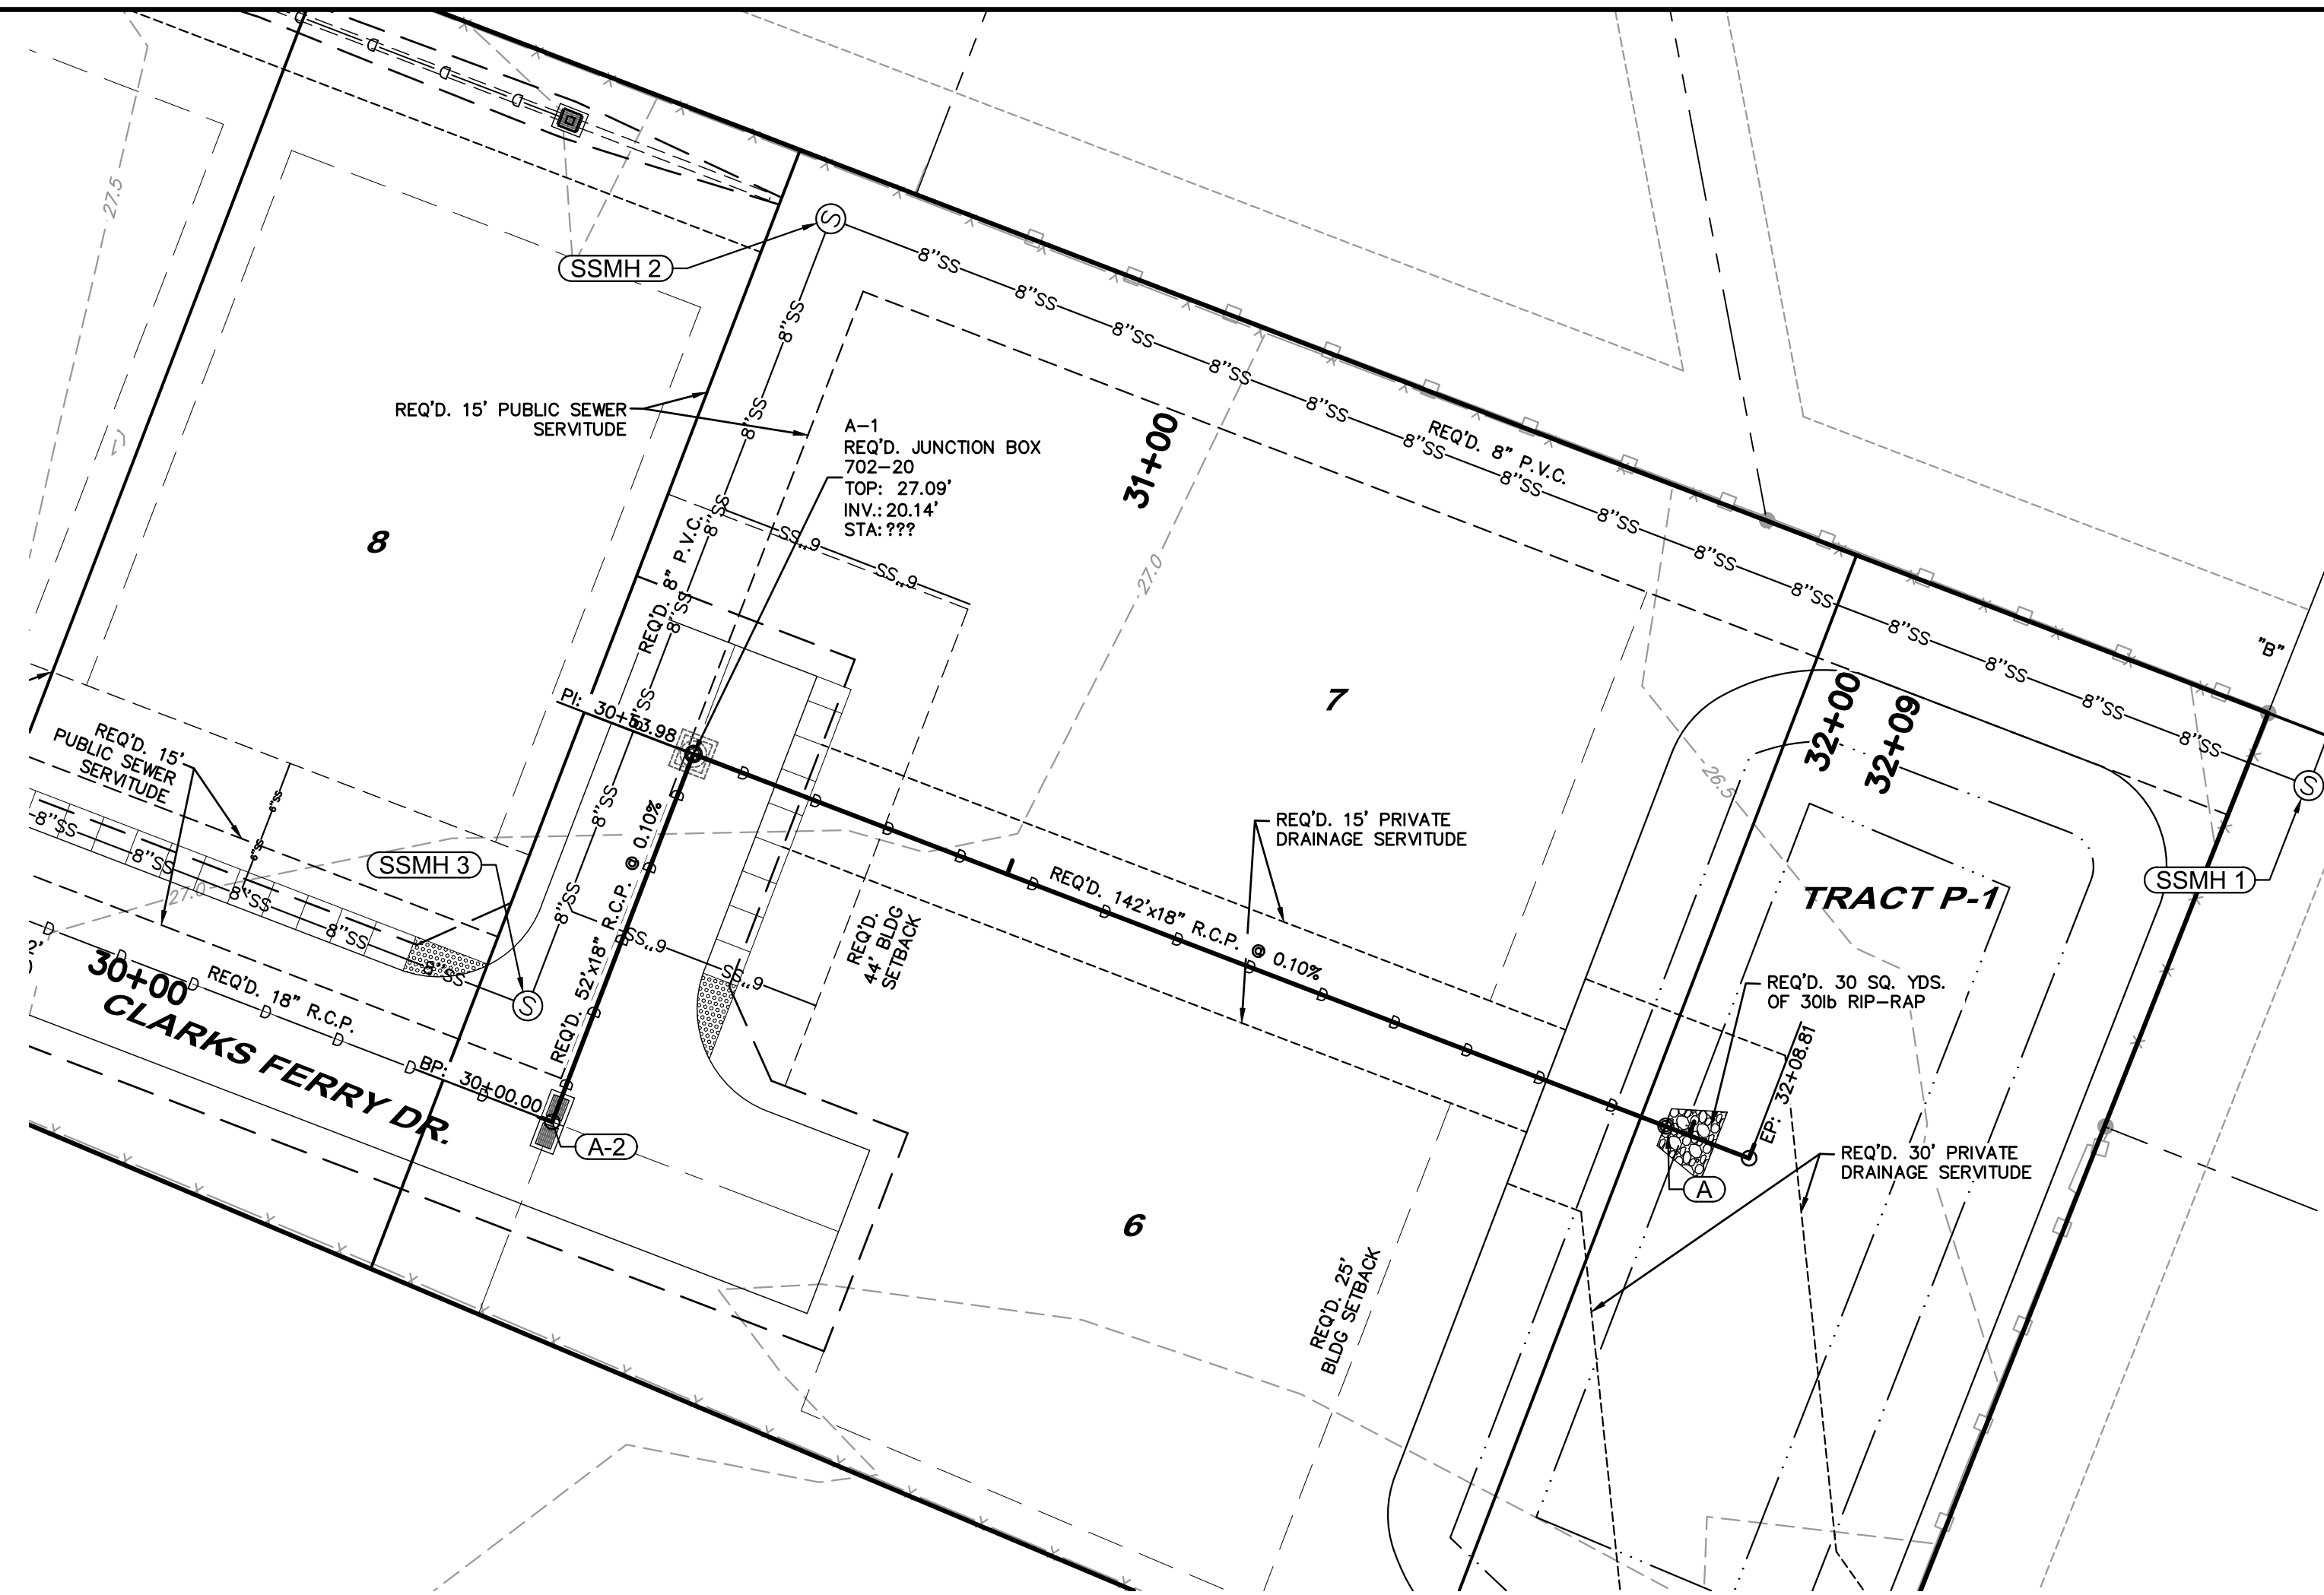


CLARK'S FERRY SUBDIVISION HOO SHOO TOO RD. BATON ROUGE EAST BATON ROUGE PARISH		DESIGNED CHECKED CMS	JOB CMS	MR ENGINEERING & SURVEYING, LLC 9345 Interline Avenue, Baton Rouge, LA 70809 225.490.9592	
OUTFALL A PLAN & PROFILE		DATE SHEET	12/2018 8 OF 17	CHAD STEVENS REG. No. 31632 REGISTERED PROFESSIONAL ENGINEER IN ENGINEERING	
REVISION DESCRIPTION		BY	SHEET NUMBER 8		





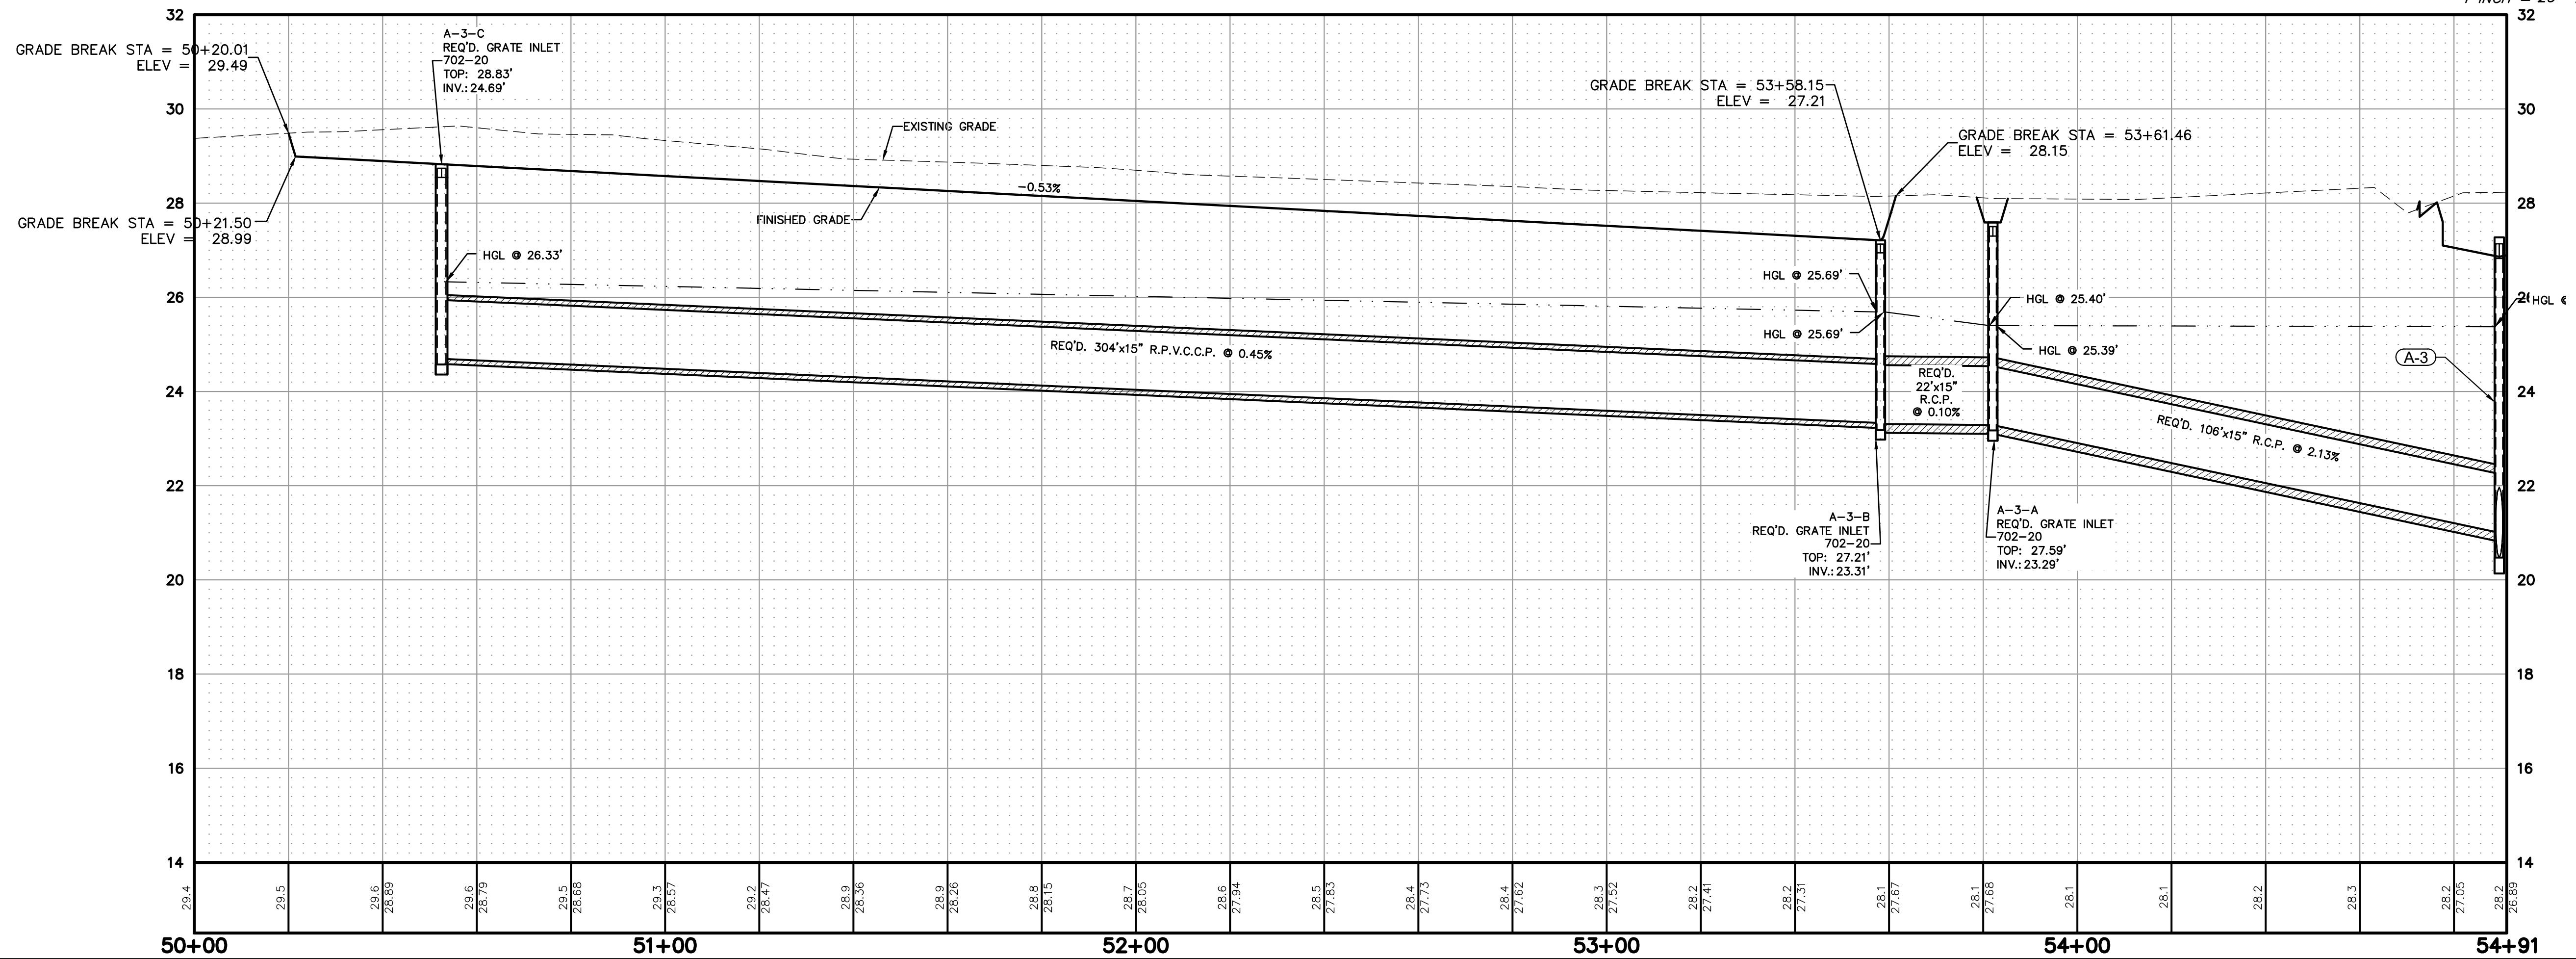
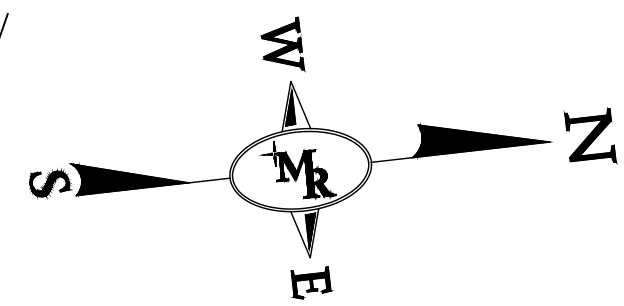


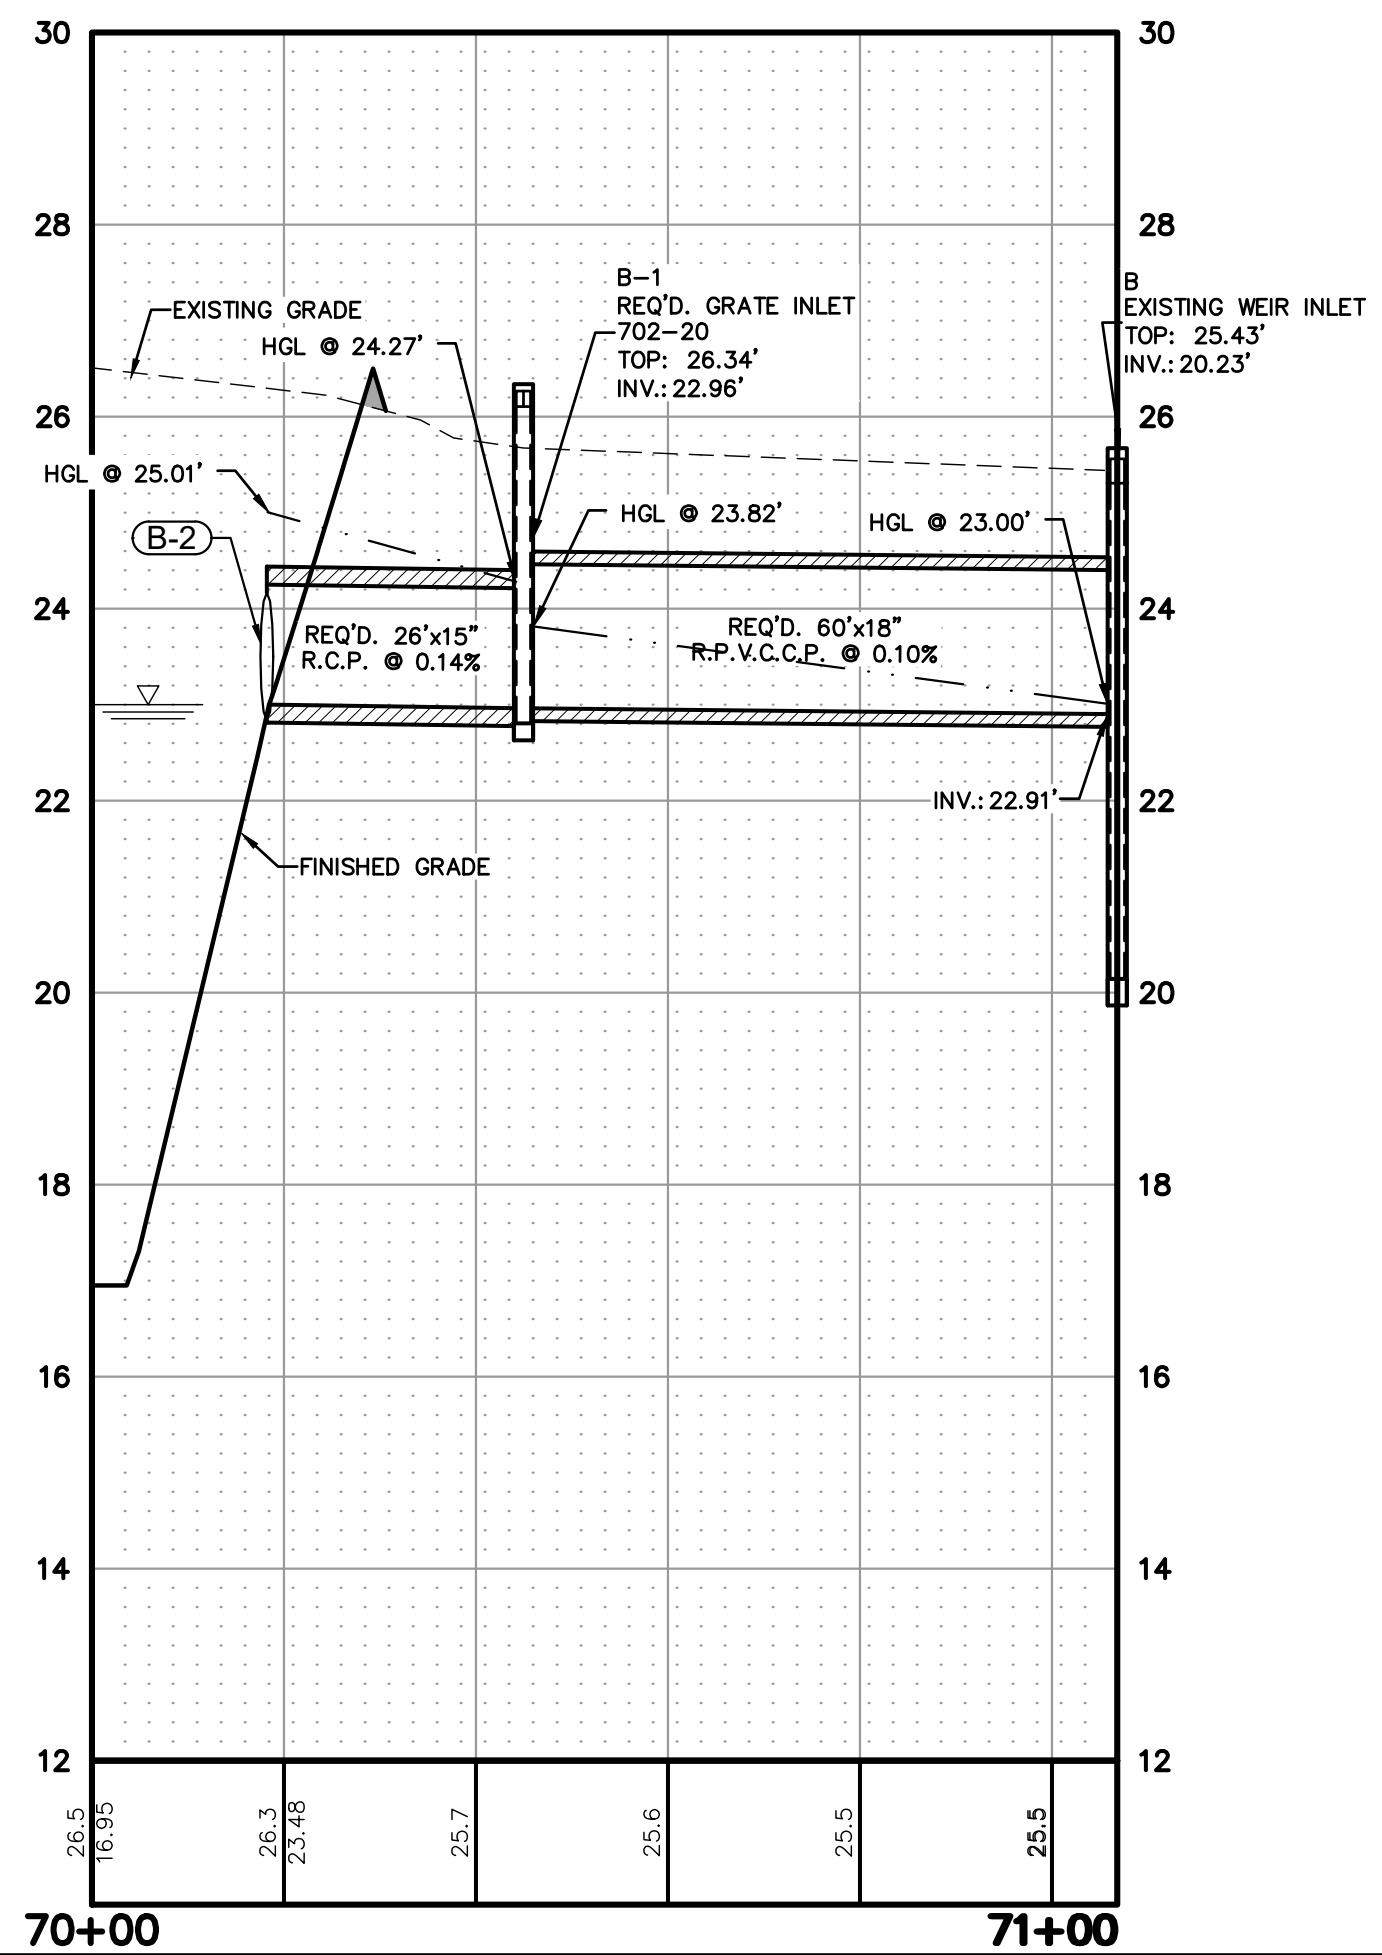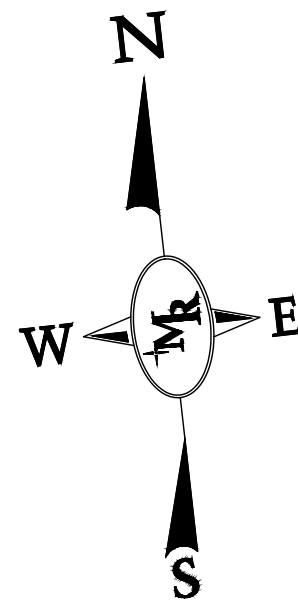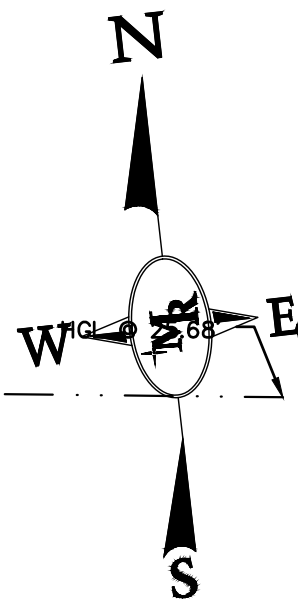

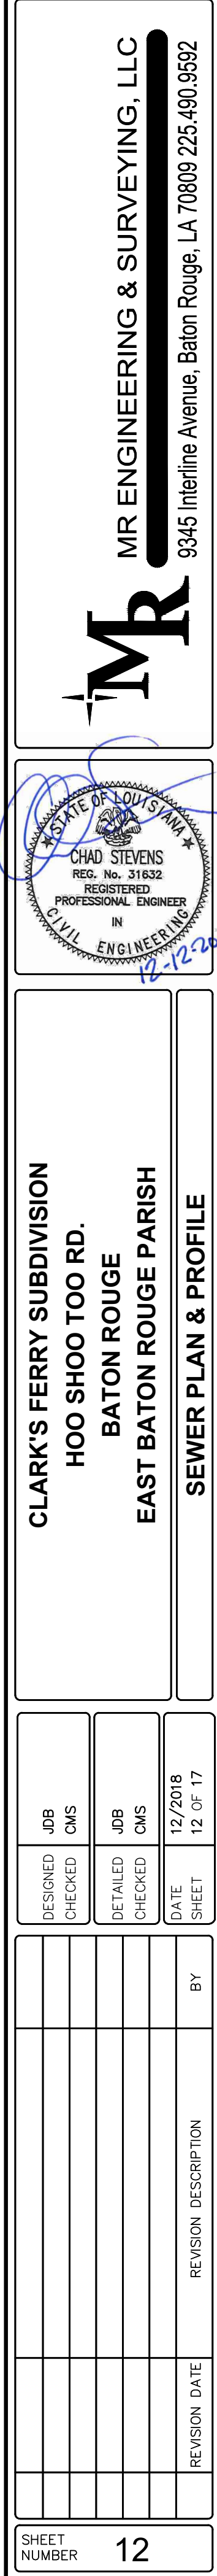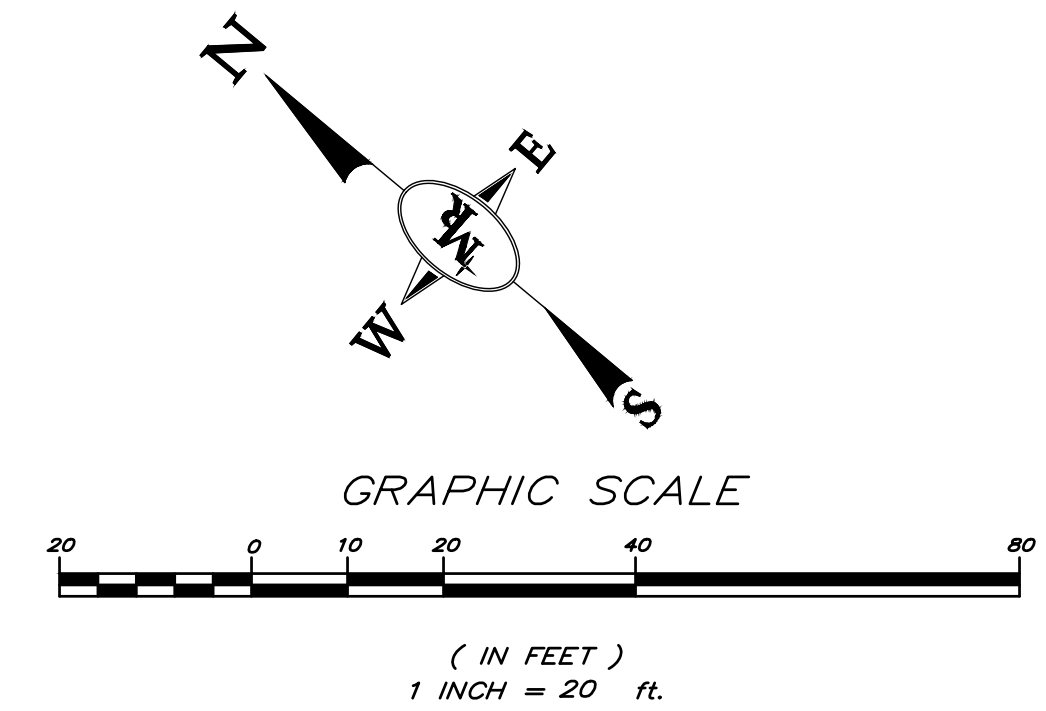

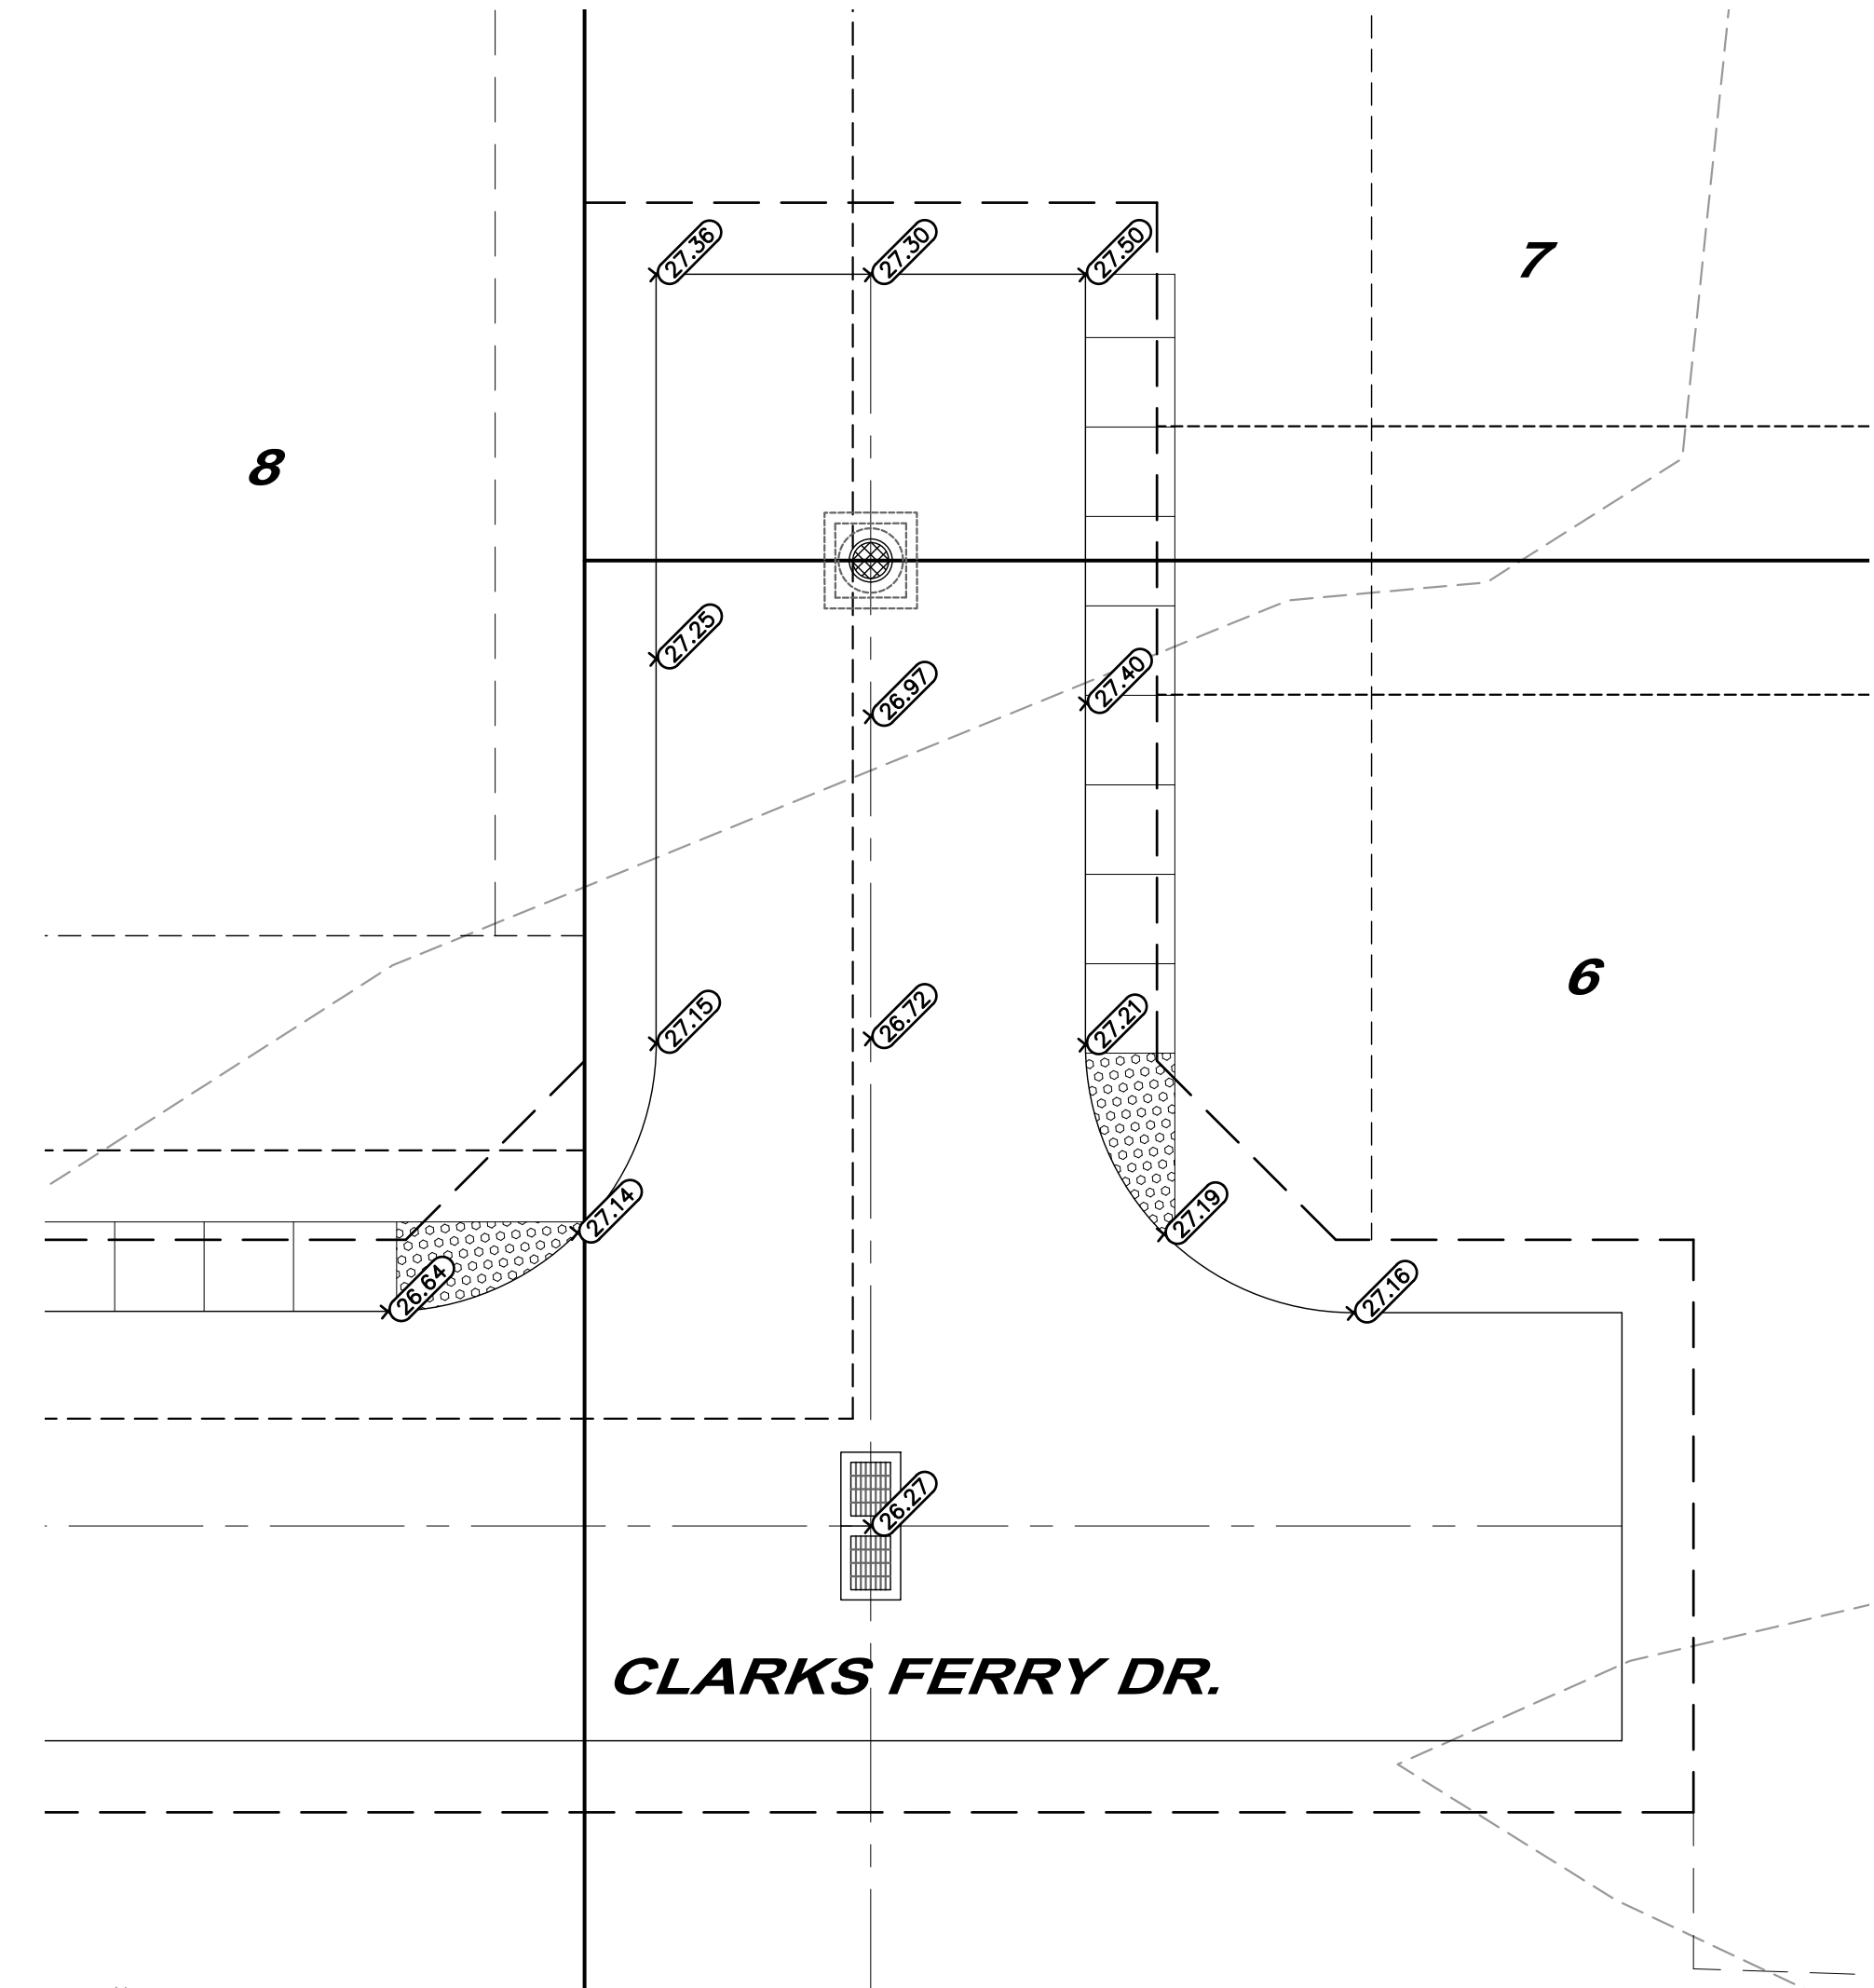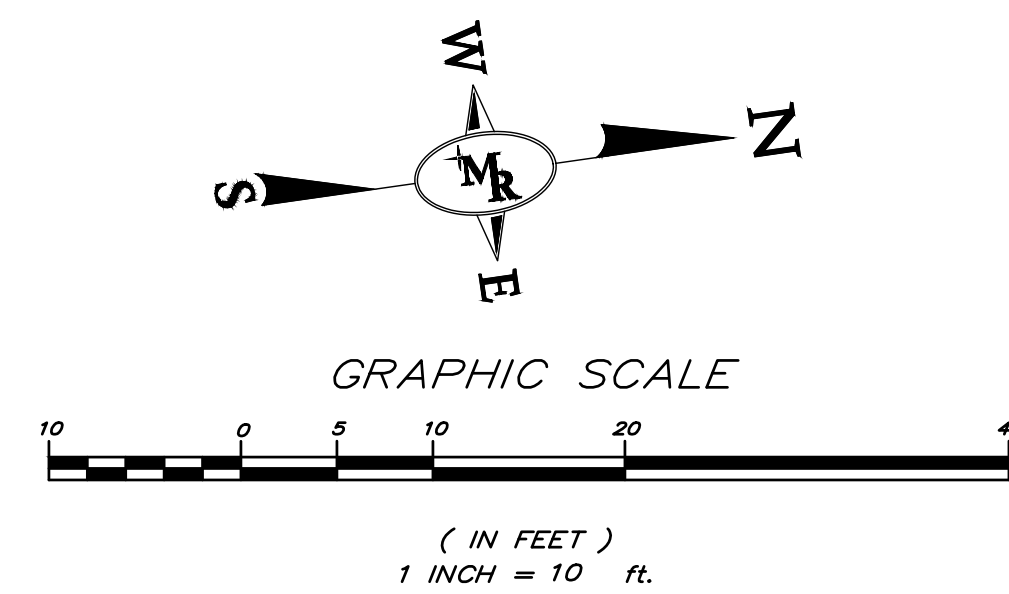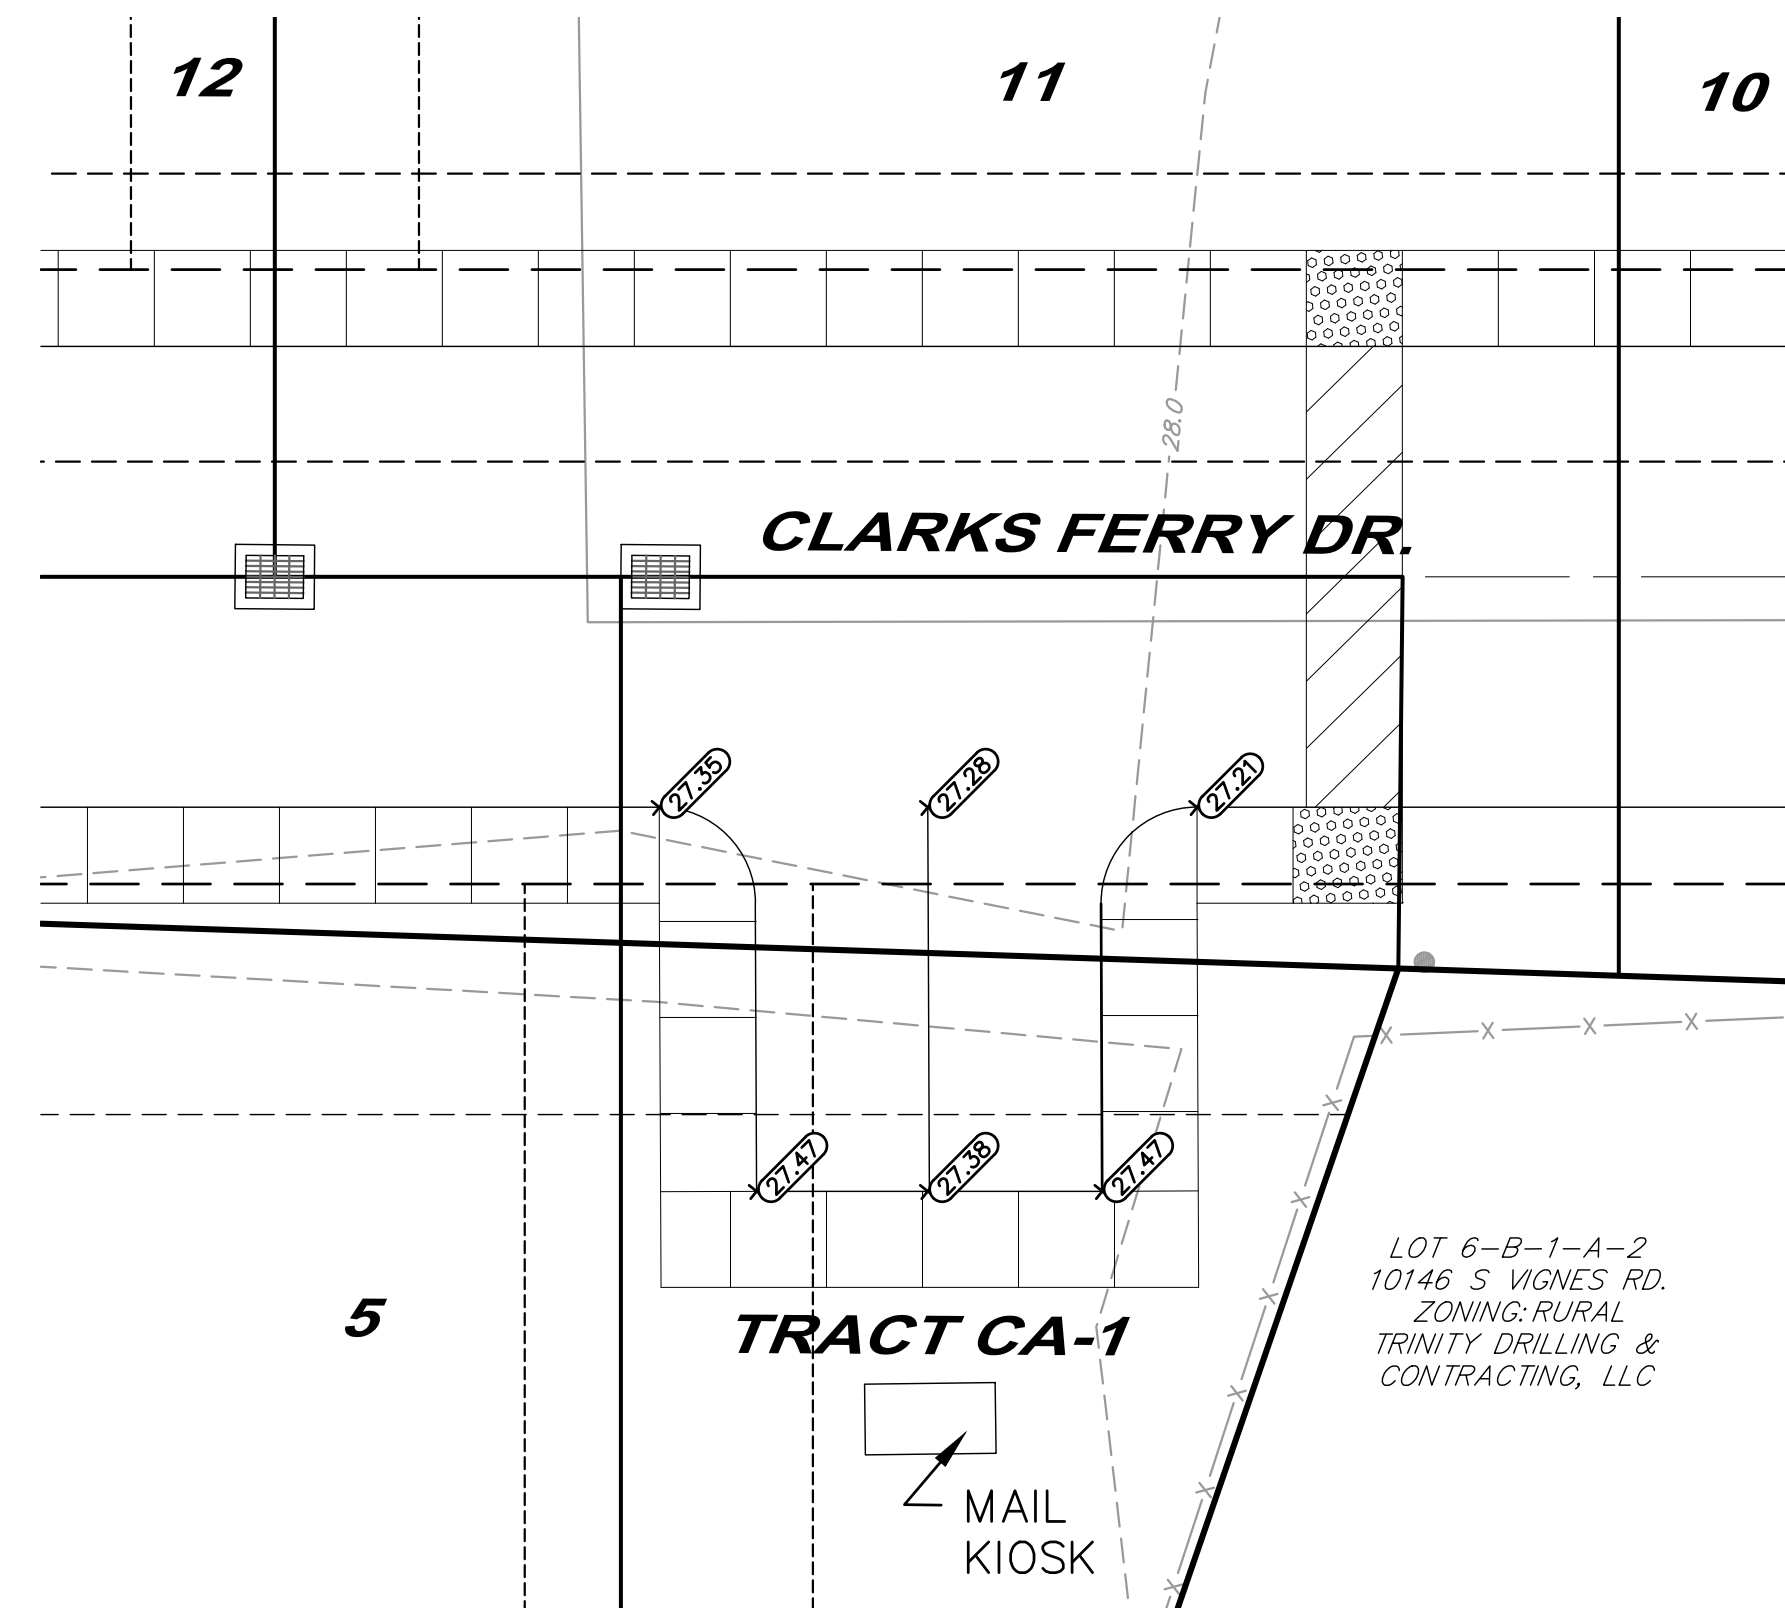[illegible]

   ① STREET SIGN (WHITE ON BLUE
STREET NAME SIGNS WITH
BLOCK NUMBERS/LETTERS PER
CITY/PARISH STANDARDS) TYPE
8 SHEETING

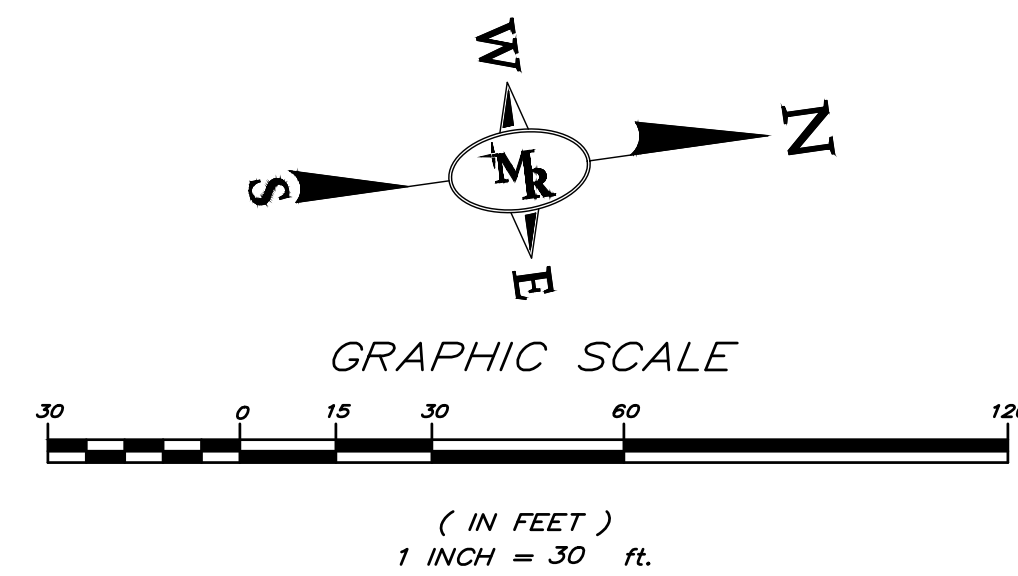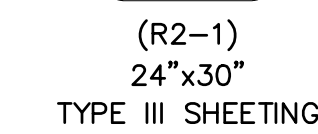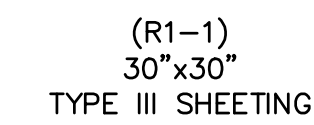[illegible]







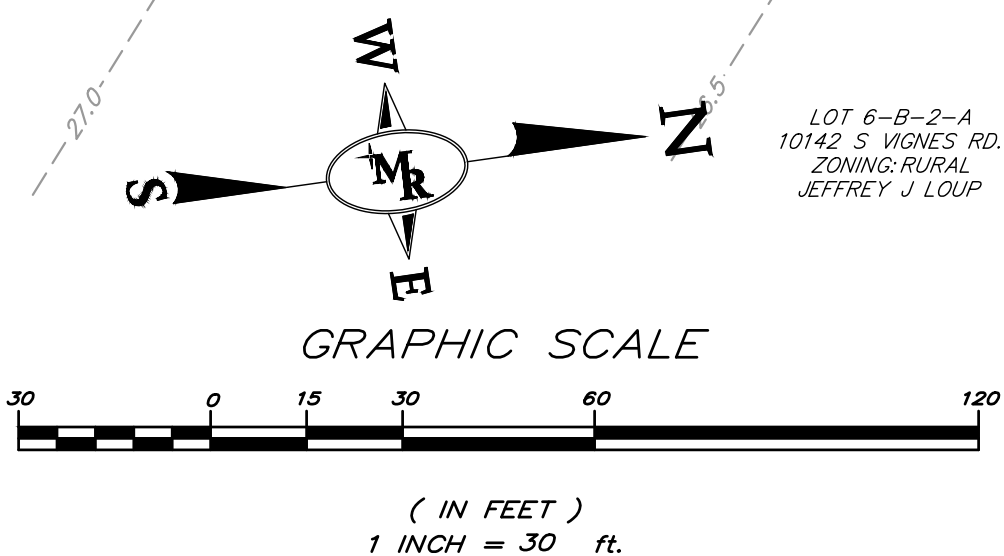


Figure 1 consists of two vertically stacked plots showing the evolution of the effective number of degrees of freedom, g_{eff} , as a function of the logarithm of the scale factor, $\ln(a/a_0)$. The x-axis for both plots ranges from 0 to 260, and the y-axis ranges from 25 to 35. The top plot is labeled "1+00" and the bottom plot is labeled "0+00". Both plots show a solid line representing the numerical evolution and a dashed line representing the theoretical prediction. The 1+00 model shows a sharp peak in g_{eff} around $\ln(a/a_0) = 120$, while the 0+00 model shows a more gradual increase and a peak around $\ln(a/a_0) = 150$.

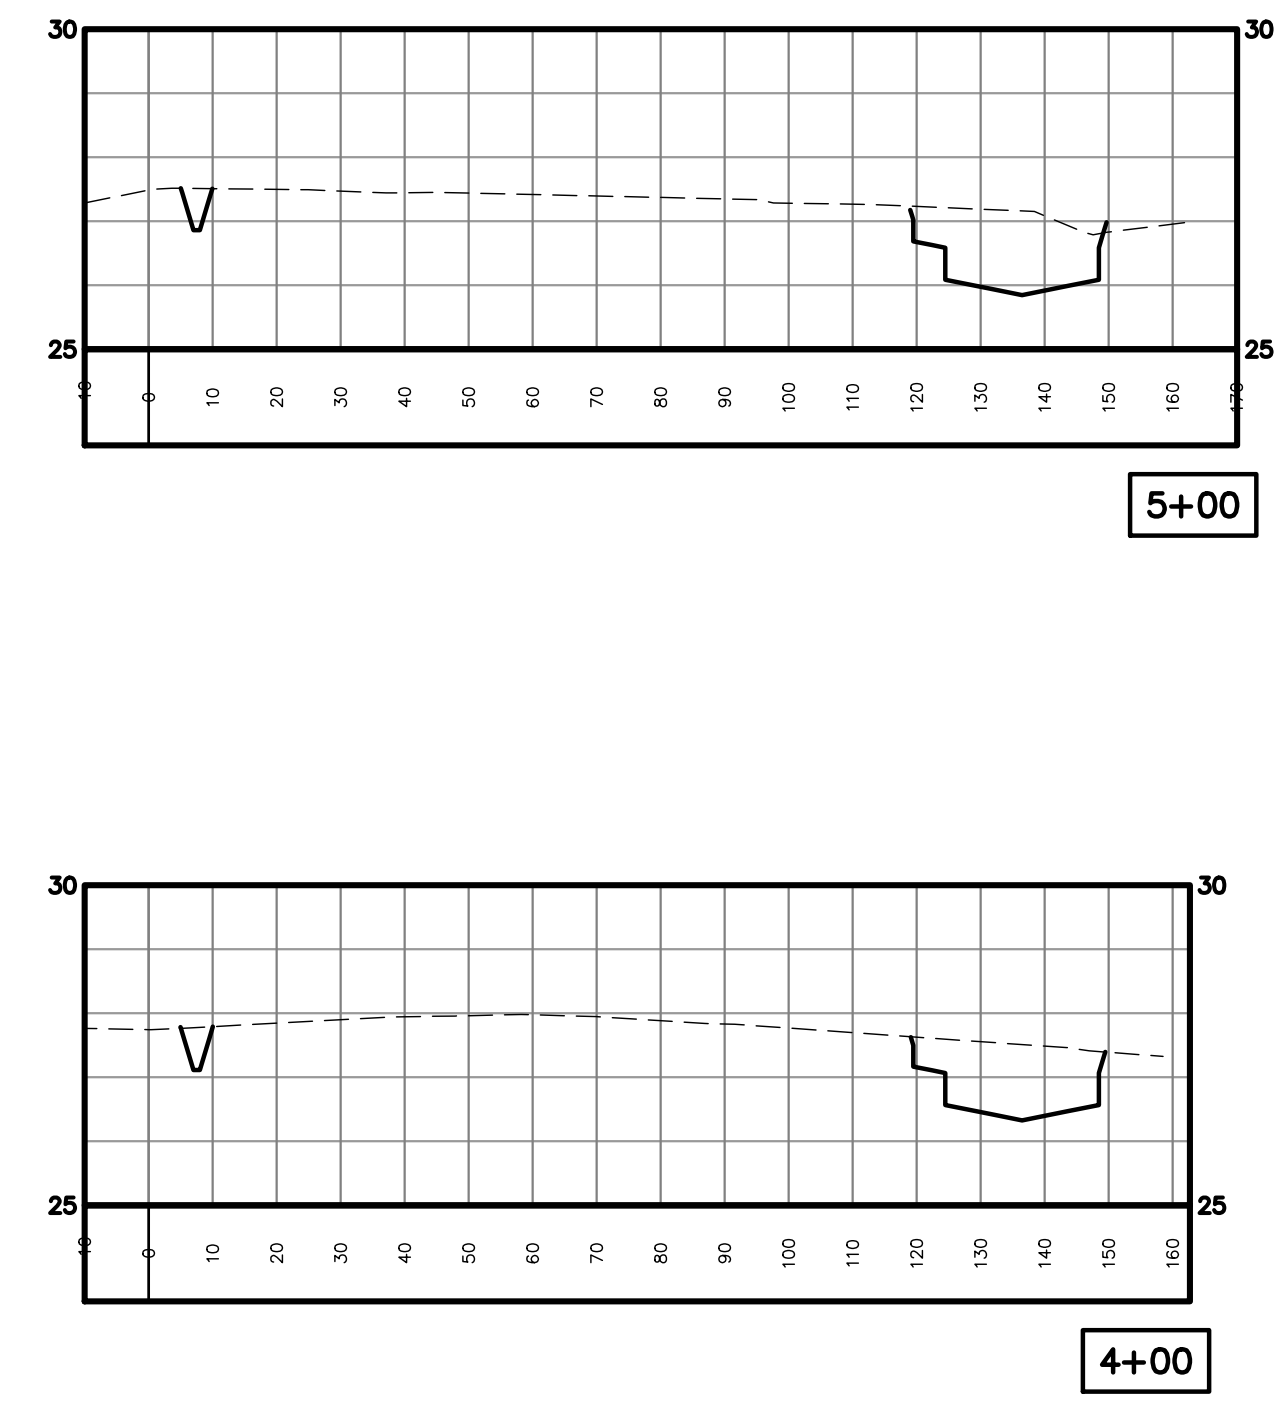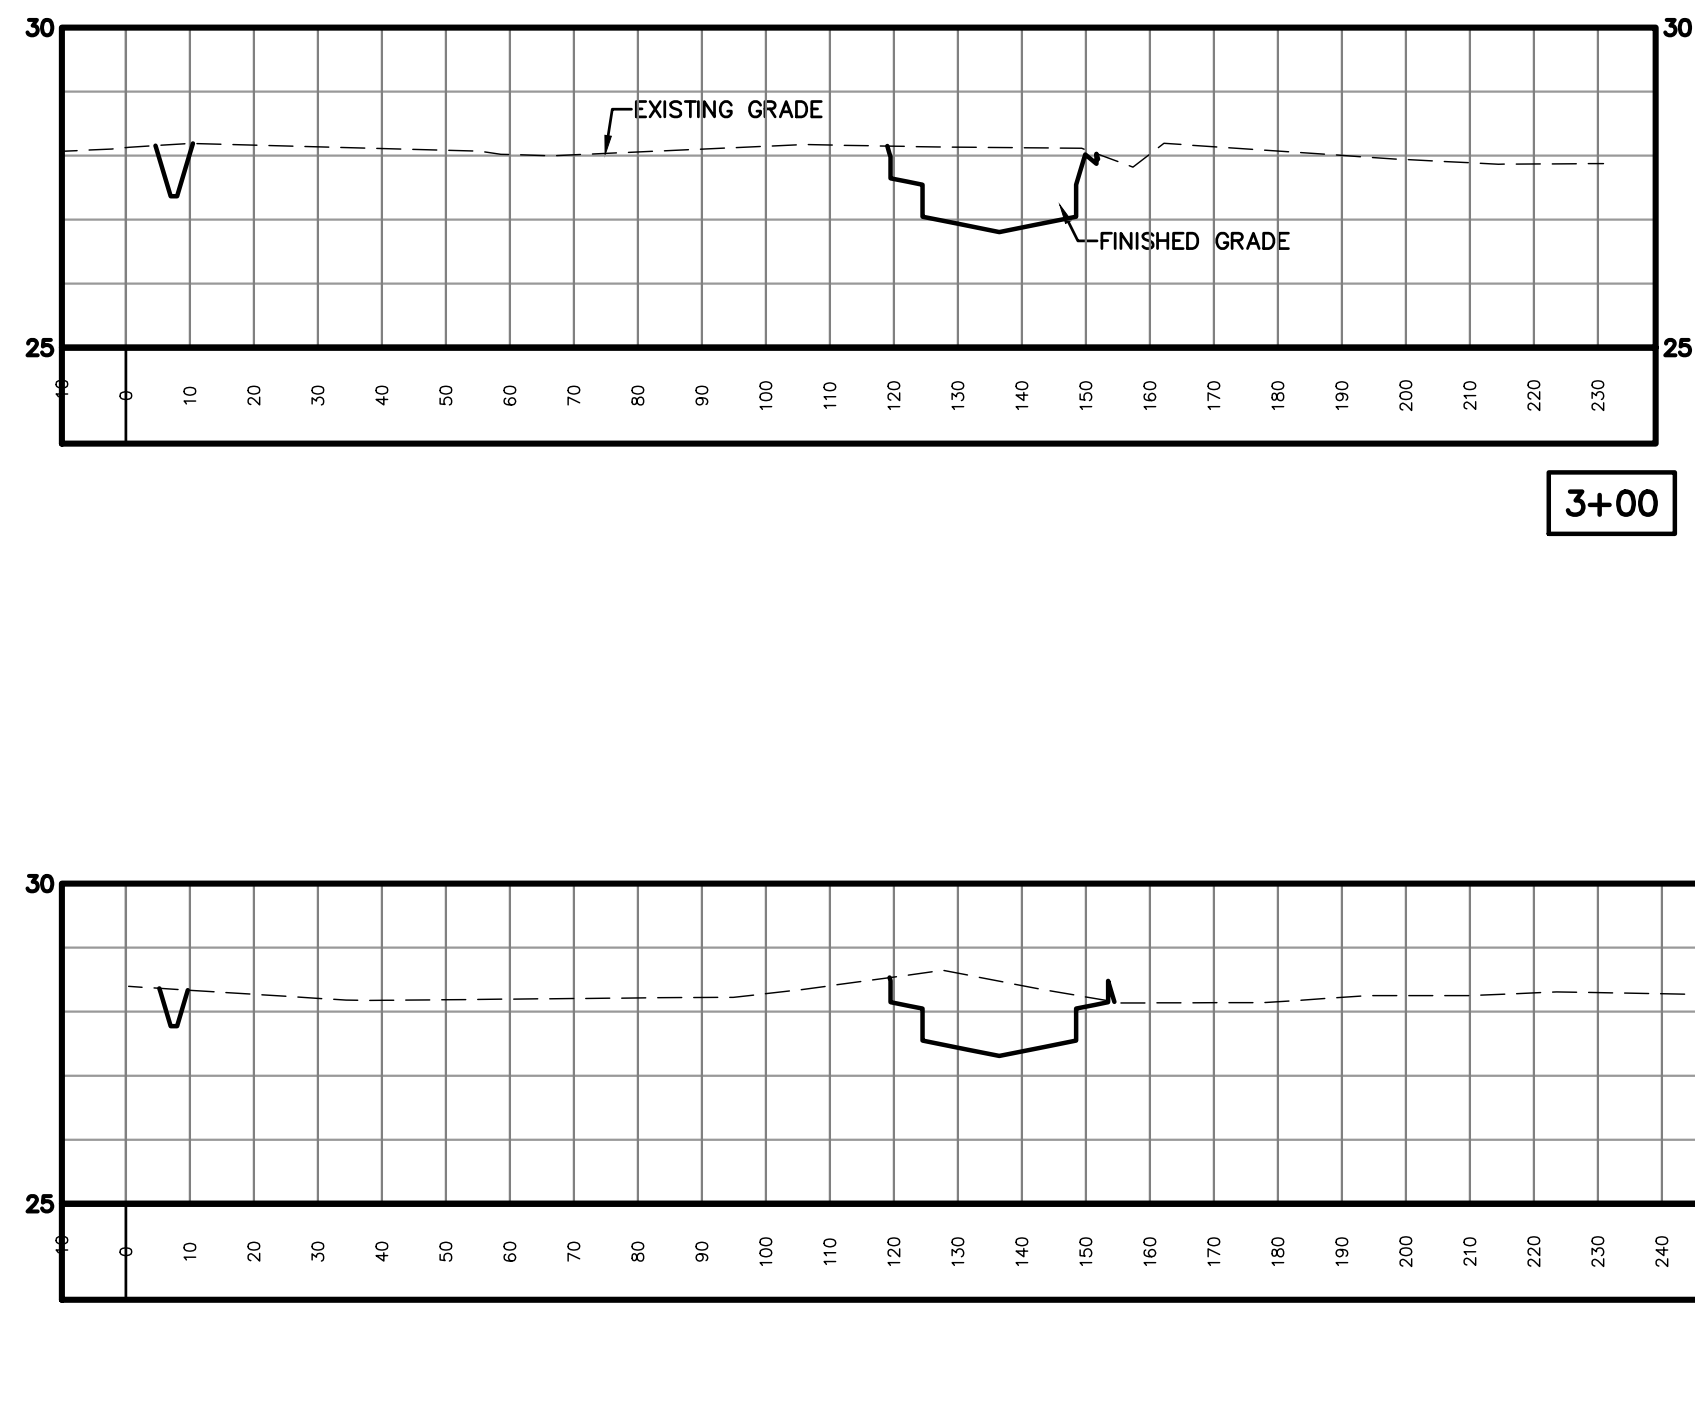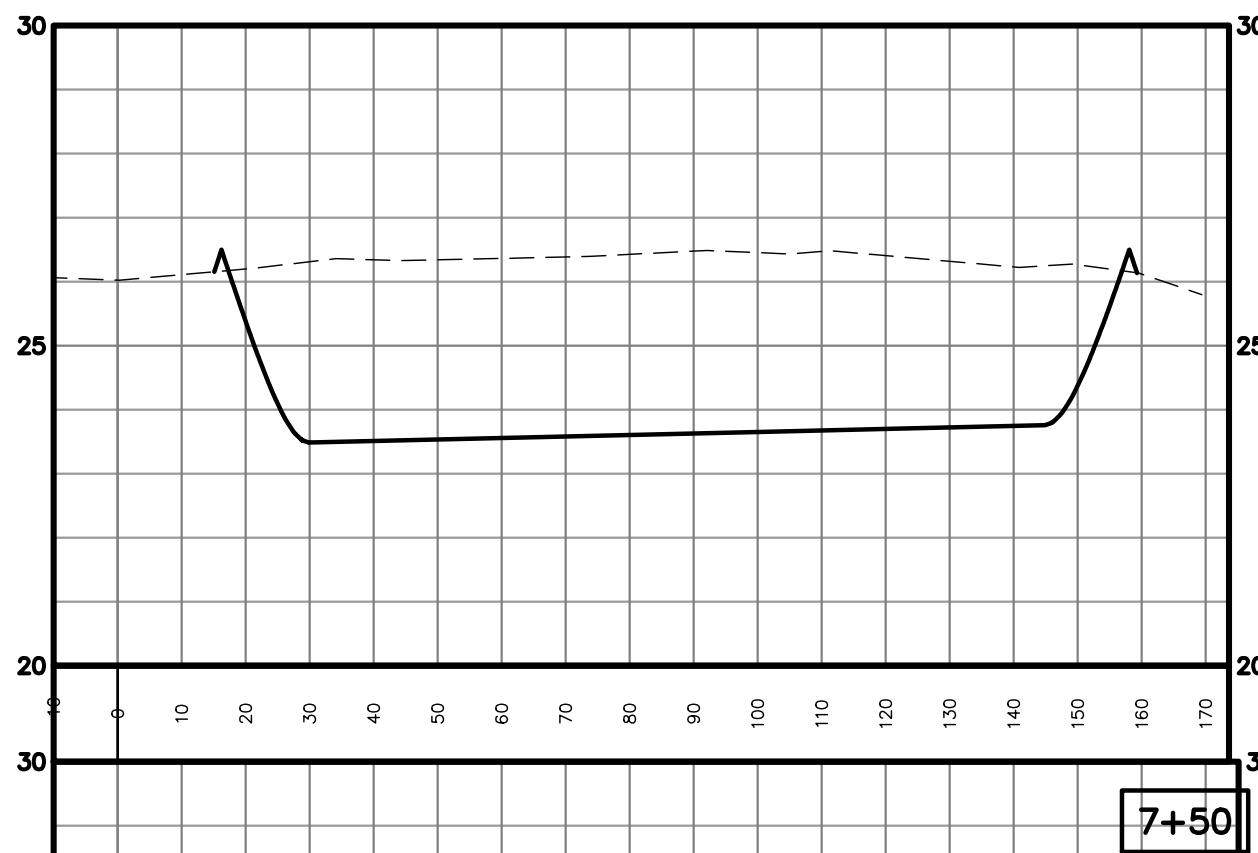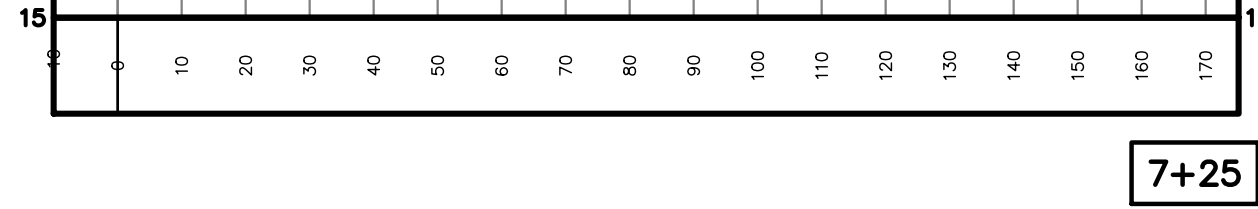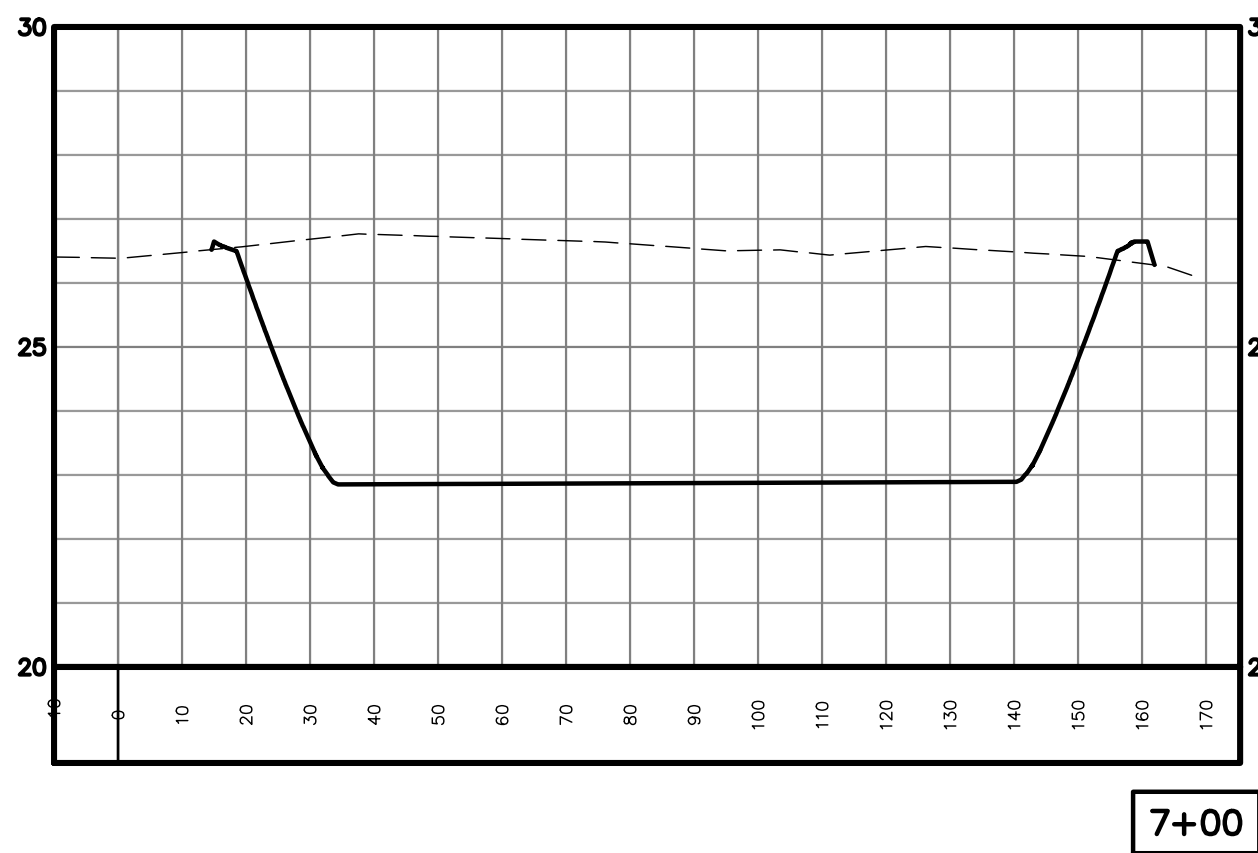

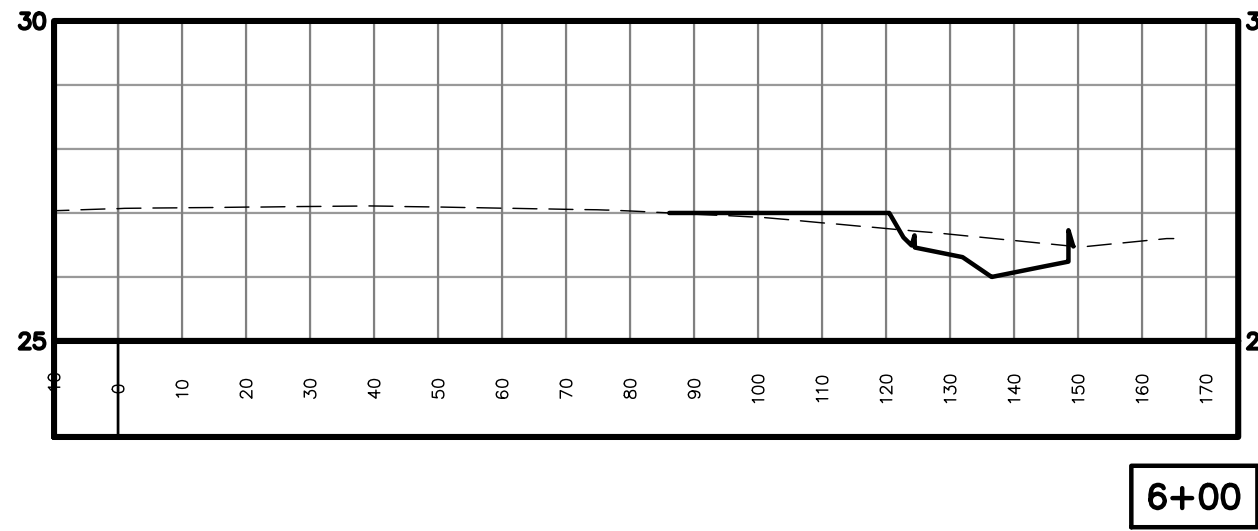


REVISION	DATE	DESCRIPTION	BY

DESIGNED	JOB
CHECKED	CMS


DATE	12/2018
SHEET	17 OF 17

CLARK'S FERRY SUBDIVISION
HOO SHOO TOO RD.
BATON ROUGE
EAST BATON ROUGE PARISH

CROSS SECTIONS

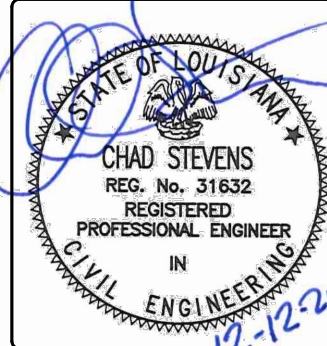

12-12-2018

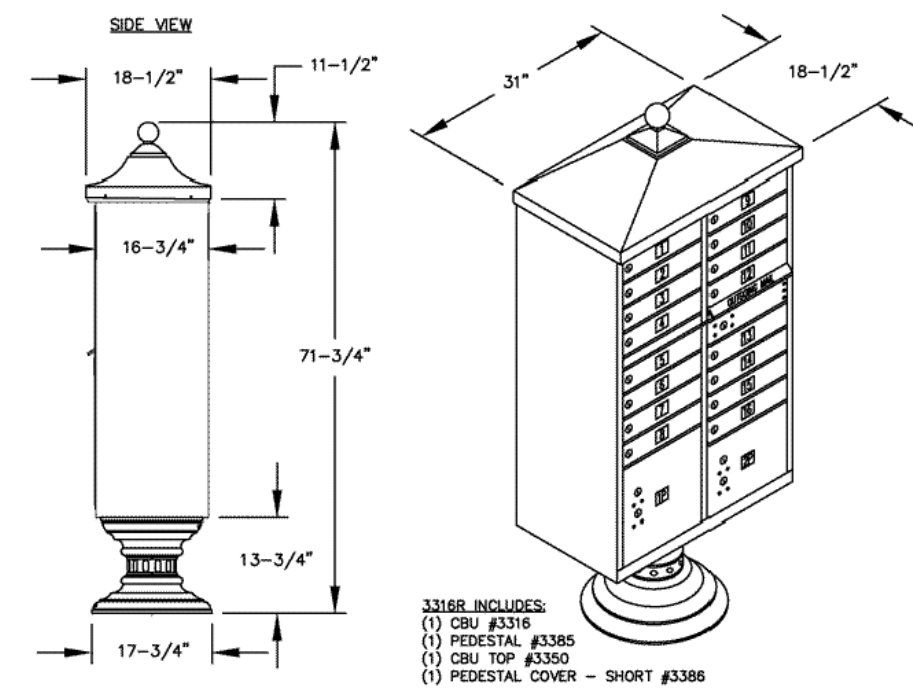

-
- A graphic scale bar is shown below the map, with markings at 30, 0, 15, 30, 60, and 120 feet. Below the scale bar, the text reads: (IN FEET)
1 INCH = 30 ft.
- A compass rose is located in the upper right corner of the map, indicating North (N), South (S), East (E), and West (W). The letters 'M' and 'R' are written inside the compass rose.

STATE OF LOUISIANA
★ ★
MICKEY L. ROBERTSON
REG. No. 4869
REGISTERED
PROFESSIONAL
LAND SURVEYOR

PUBLIC DEDICATION:

THE RIGHTS OF WAY SHOWN HEREON, IF NOT PREVIOUSLY DEDICATED, ARE HEREBY DEDICATED TO THE SUPREMACY AND USE OF THE PUBLIC FOR PROPER PURPOSES. ALL AREAS SHOWN AS SERVICED ARE GRANTED TO THE PUBLIC FOR USE OF UTILITIES, DRAINAGE, SEWAGE REMOVAL OR OTHER NECESSARY SERVICES. TREES, SHRUBS, AND THE PUBLIC, NO TREES, SHRUBS, OR OTHER PLANTS MAY BE PLANTED, NOR SHALL ANY BUILDING, FENCE, STRUCTURE OR IMPROVEMENTS BE CONSTRUCTED OR INSTALLED WITHIN OR OVER THE PUBLIC RIGHT-OF-WAY SO AS TO PREVENT OR UNREASONABLY INTERFERE WITH ANY PURPOSE FOR WHICH THE SERVICUTE OR RIGHT-OF-WAY IS GRANTED.

BASIS OF BEARING: "N06°21'21"E

WEST PROPERTY LINE BASED ON G.P.S. OBSERVATION, "A" TO "B"

REFERENCE MAPS:

1) SURVEY MAP OF THE RESUBDIVISION OF A 1.119 AC TRACT BEING A PORTION OF LOT 5 AND LOT 6 OF THE JOSEPH HEARD TRACT, BY JOFFRION & ASSOCIATES, INC. DATED MARCH 31, 1978.

2) SURVEY MAP OF THE RESUBDIVISION OF A 3.5 AC TRACT BEING A PORTION OF LOT 6 OF THE JOSEPH HEARD TRACT, BY JOFFRION & ASSOCIATES, INC. DATED MARCH 31, 1978.

PRIVATE DEDICATION:

THE COMMON AREAS AND PRIVATE STREETS SHOWN HEREON ARE HEREBY DEDICATED TO THE COMMON USE AND THE REMOVAL OF THE RESIDENTS OF CLARK'S FERRY. ALL MAINTENANCE SHALL BE BY THE CLARK'S FERRY HOMEOWNERS ASSOCIATION. DPW SHALL NOT BE RESPONSIBLE FOR THE MAINTENANCE OR UPKEEP OF THE LAKES, SHORELINE, OR ANY OTHER

CERTIFICATION:

I HEREBY CERTIFY THAT THE PLAT SHOWN WAS MADE IN ACCORDANCE WITH LOUISIANA REVISED STATUTES 33:5051, ET. SEQ., AND CONFORMS TO ALL OTHER ORDINANCES GOVERNING THE SUBDIVISION OF LAND AND TO THE MINIMUM STANDARD FOR "PROPERTY BOUNDARY SURVEYS" FOR A "CLASS "B" SURVEY AS ESTABLISHED BY THE LOUISIANA STATE BOARD OF SURVEYORS.

Mickey L. Robertson

10-17-2018

DATE

MICKEY L. ROBERTSON, P.E., P.L.S.
SURVEYING ENGINEER

[illegible]